
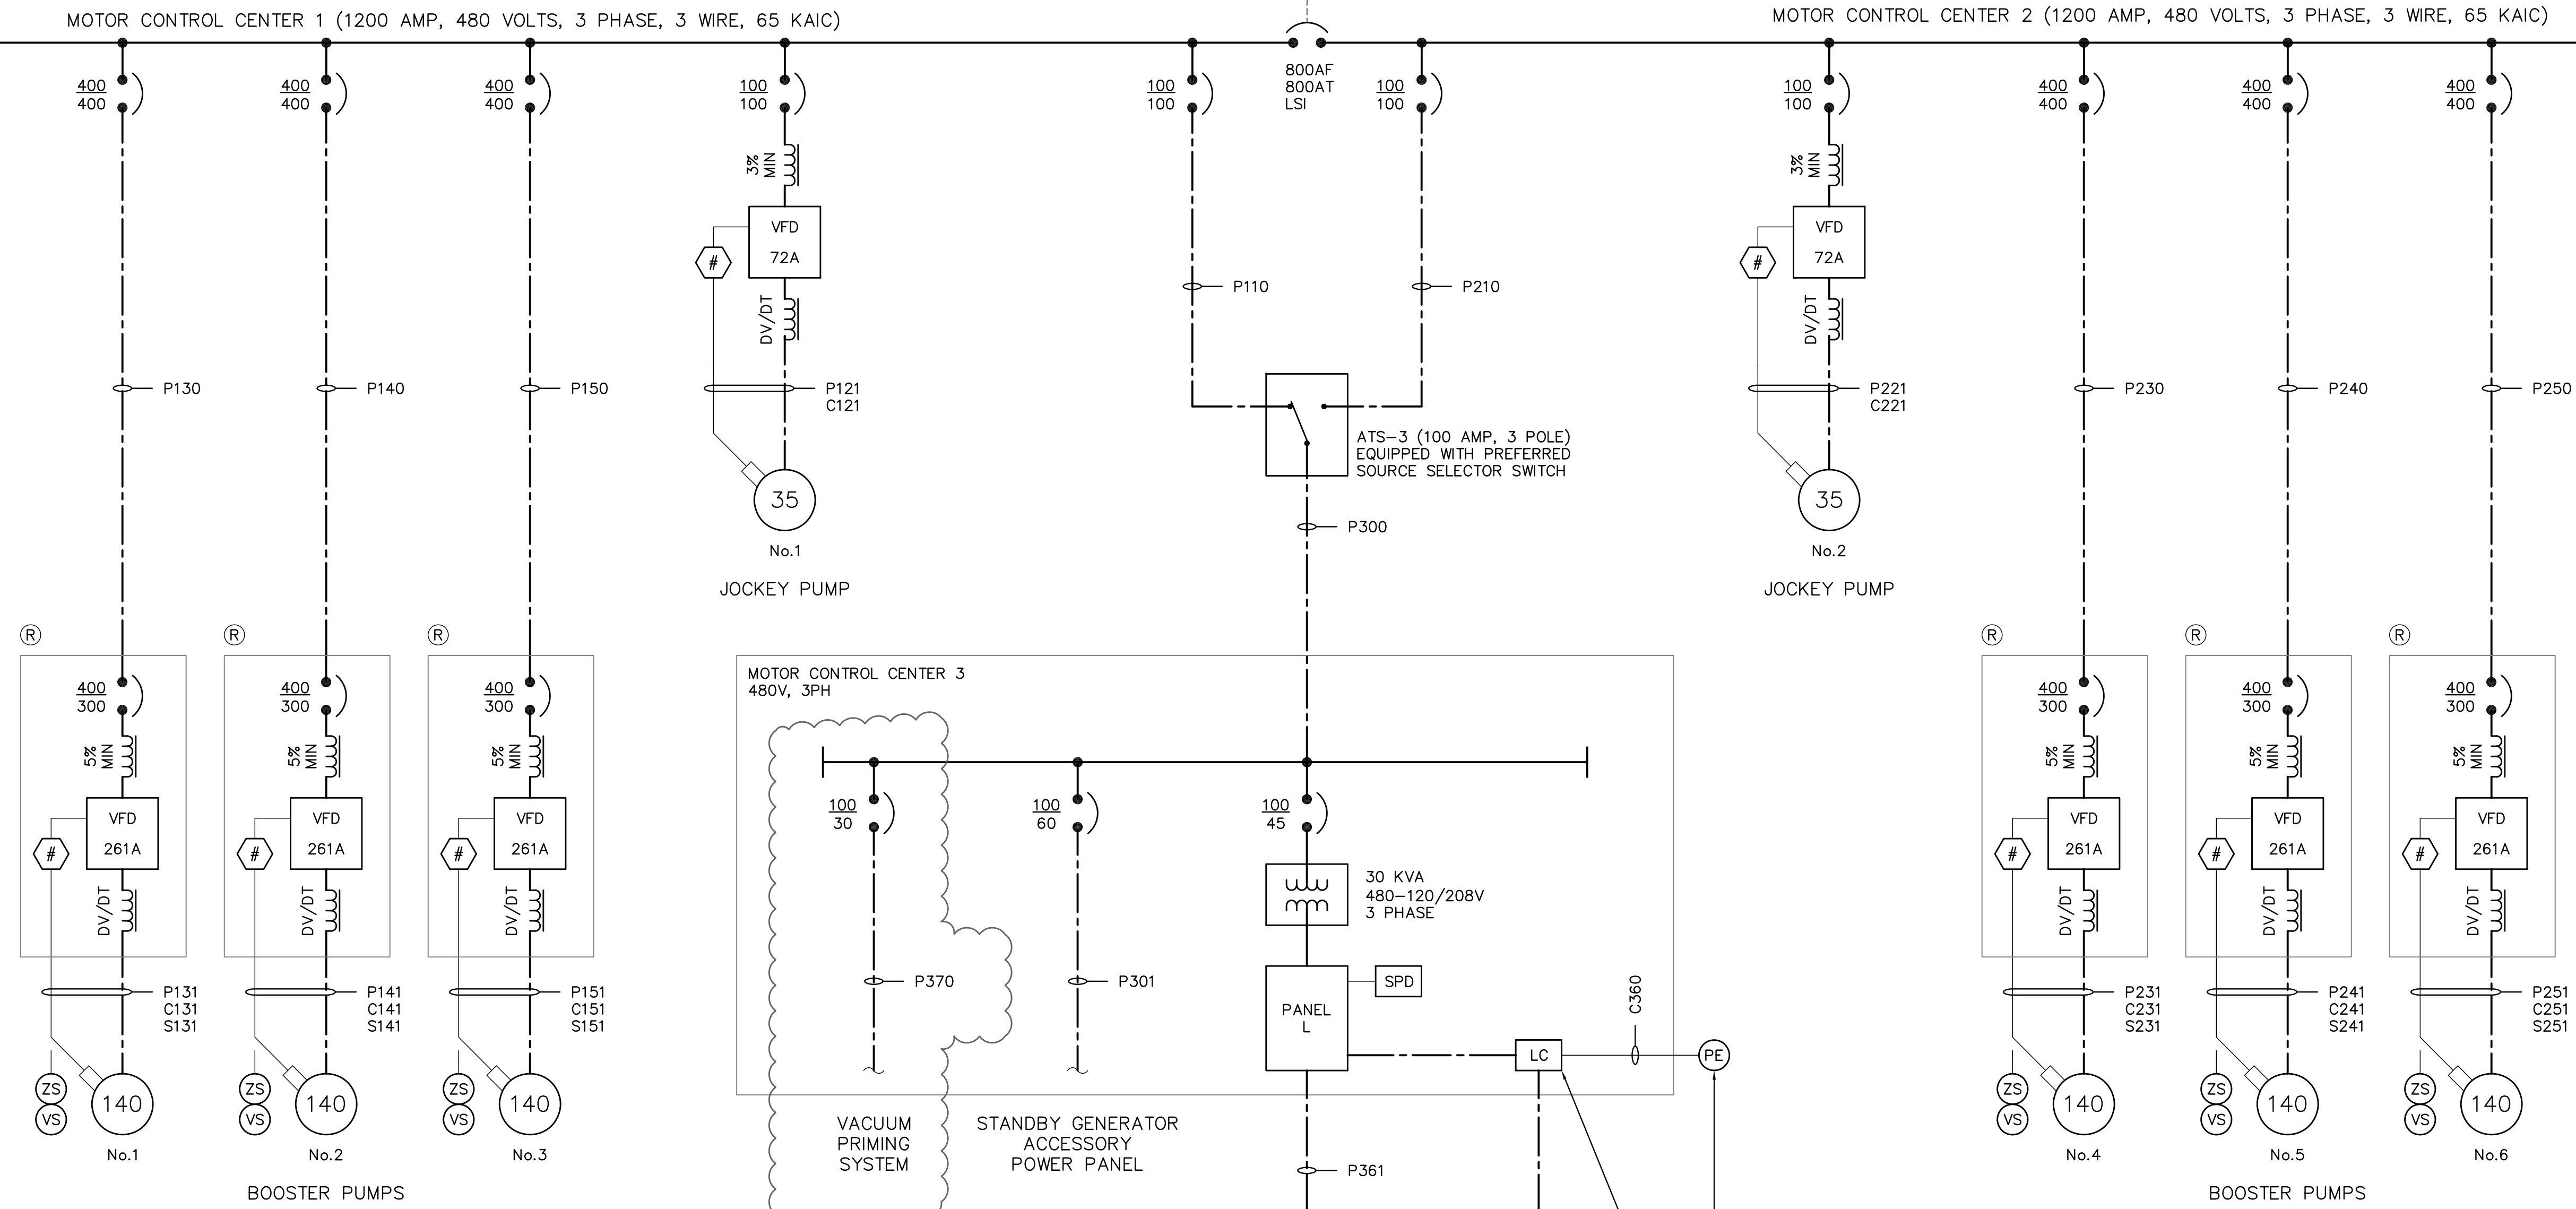


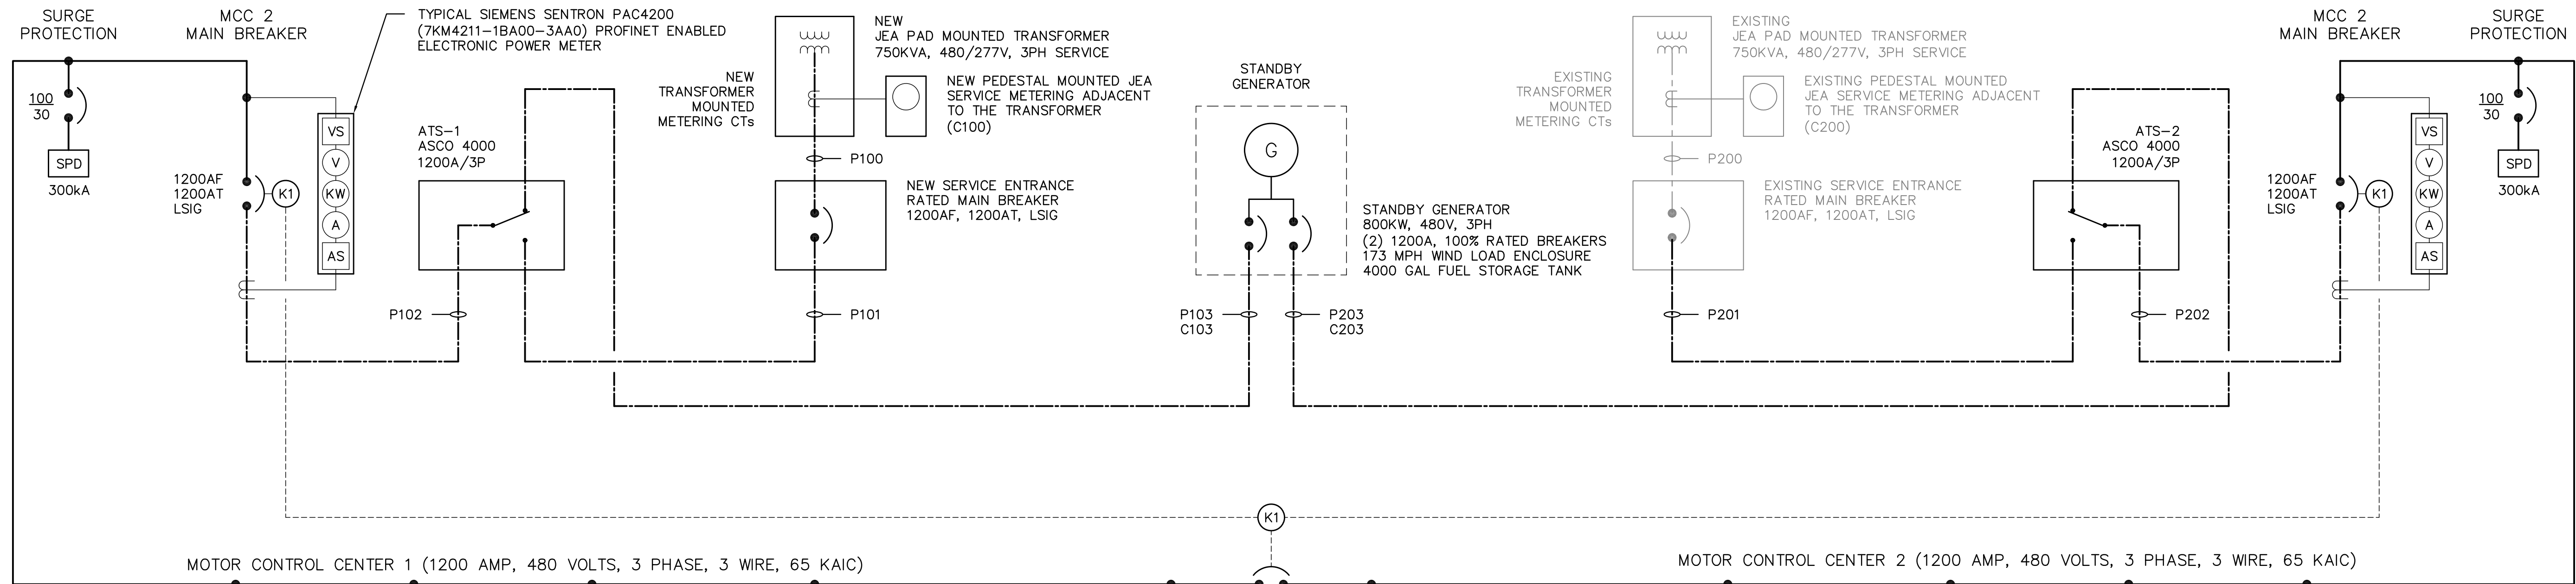

4651 Salisbury Road, Suite 420
Jacksonville, FL 32256
Tel: (904) 731-7109
FL COA No. EB-0000020

CDM Smith

WD LASSETTER PE
3837 BUCKSKIN TRAIL E.
JACKSONVILLE FL 32277
304-745-7035

NO.	BY	DATE	REVISIONS
1.			
2.			
3.			
4.			
5.			

DESIGNER:	D. LASSETTER
DRAWN BY:	D. LASSETTER
CHECKED BY:	CDM SMITH
DATE:	MAY 2019

JEA
Building Communitysm

**JEA, BRADLEY ROAD
WASTEWATER BOOSTER PUMP STATION
ELECTRICAL SINGLE LINE DIAGRAM**

PROJ. NO.	6103-108860
DATE:	MAY 2019
SCALE:	AS SHOWN

NO. SHEETS	54
SHEET NO.	54
DRAWING NO.	E-4