

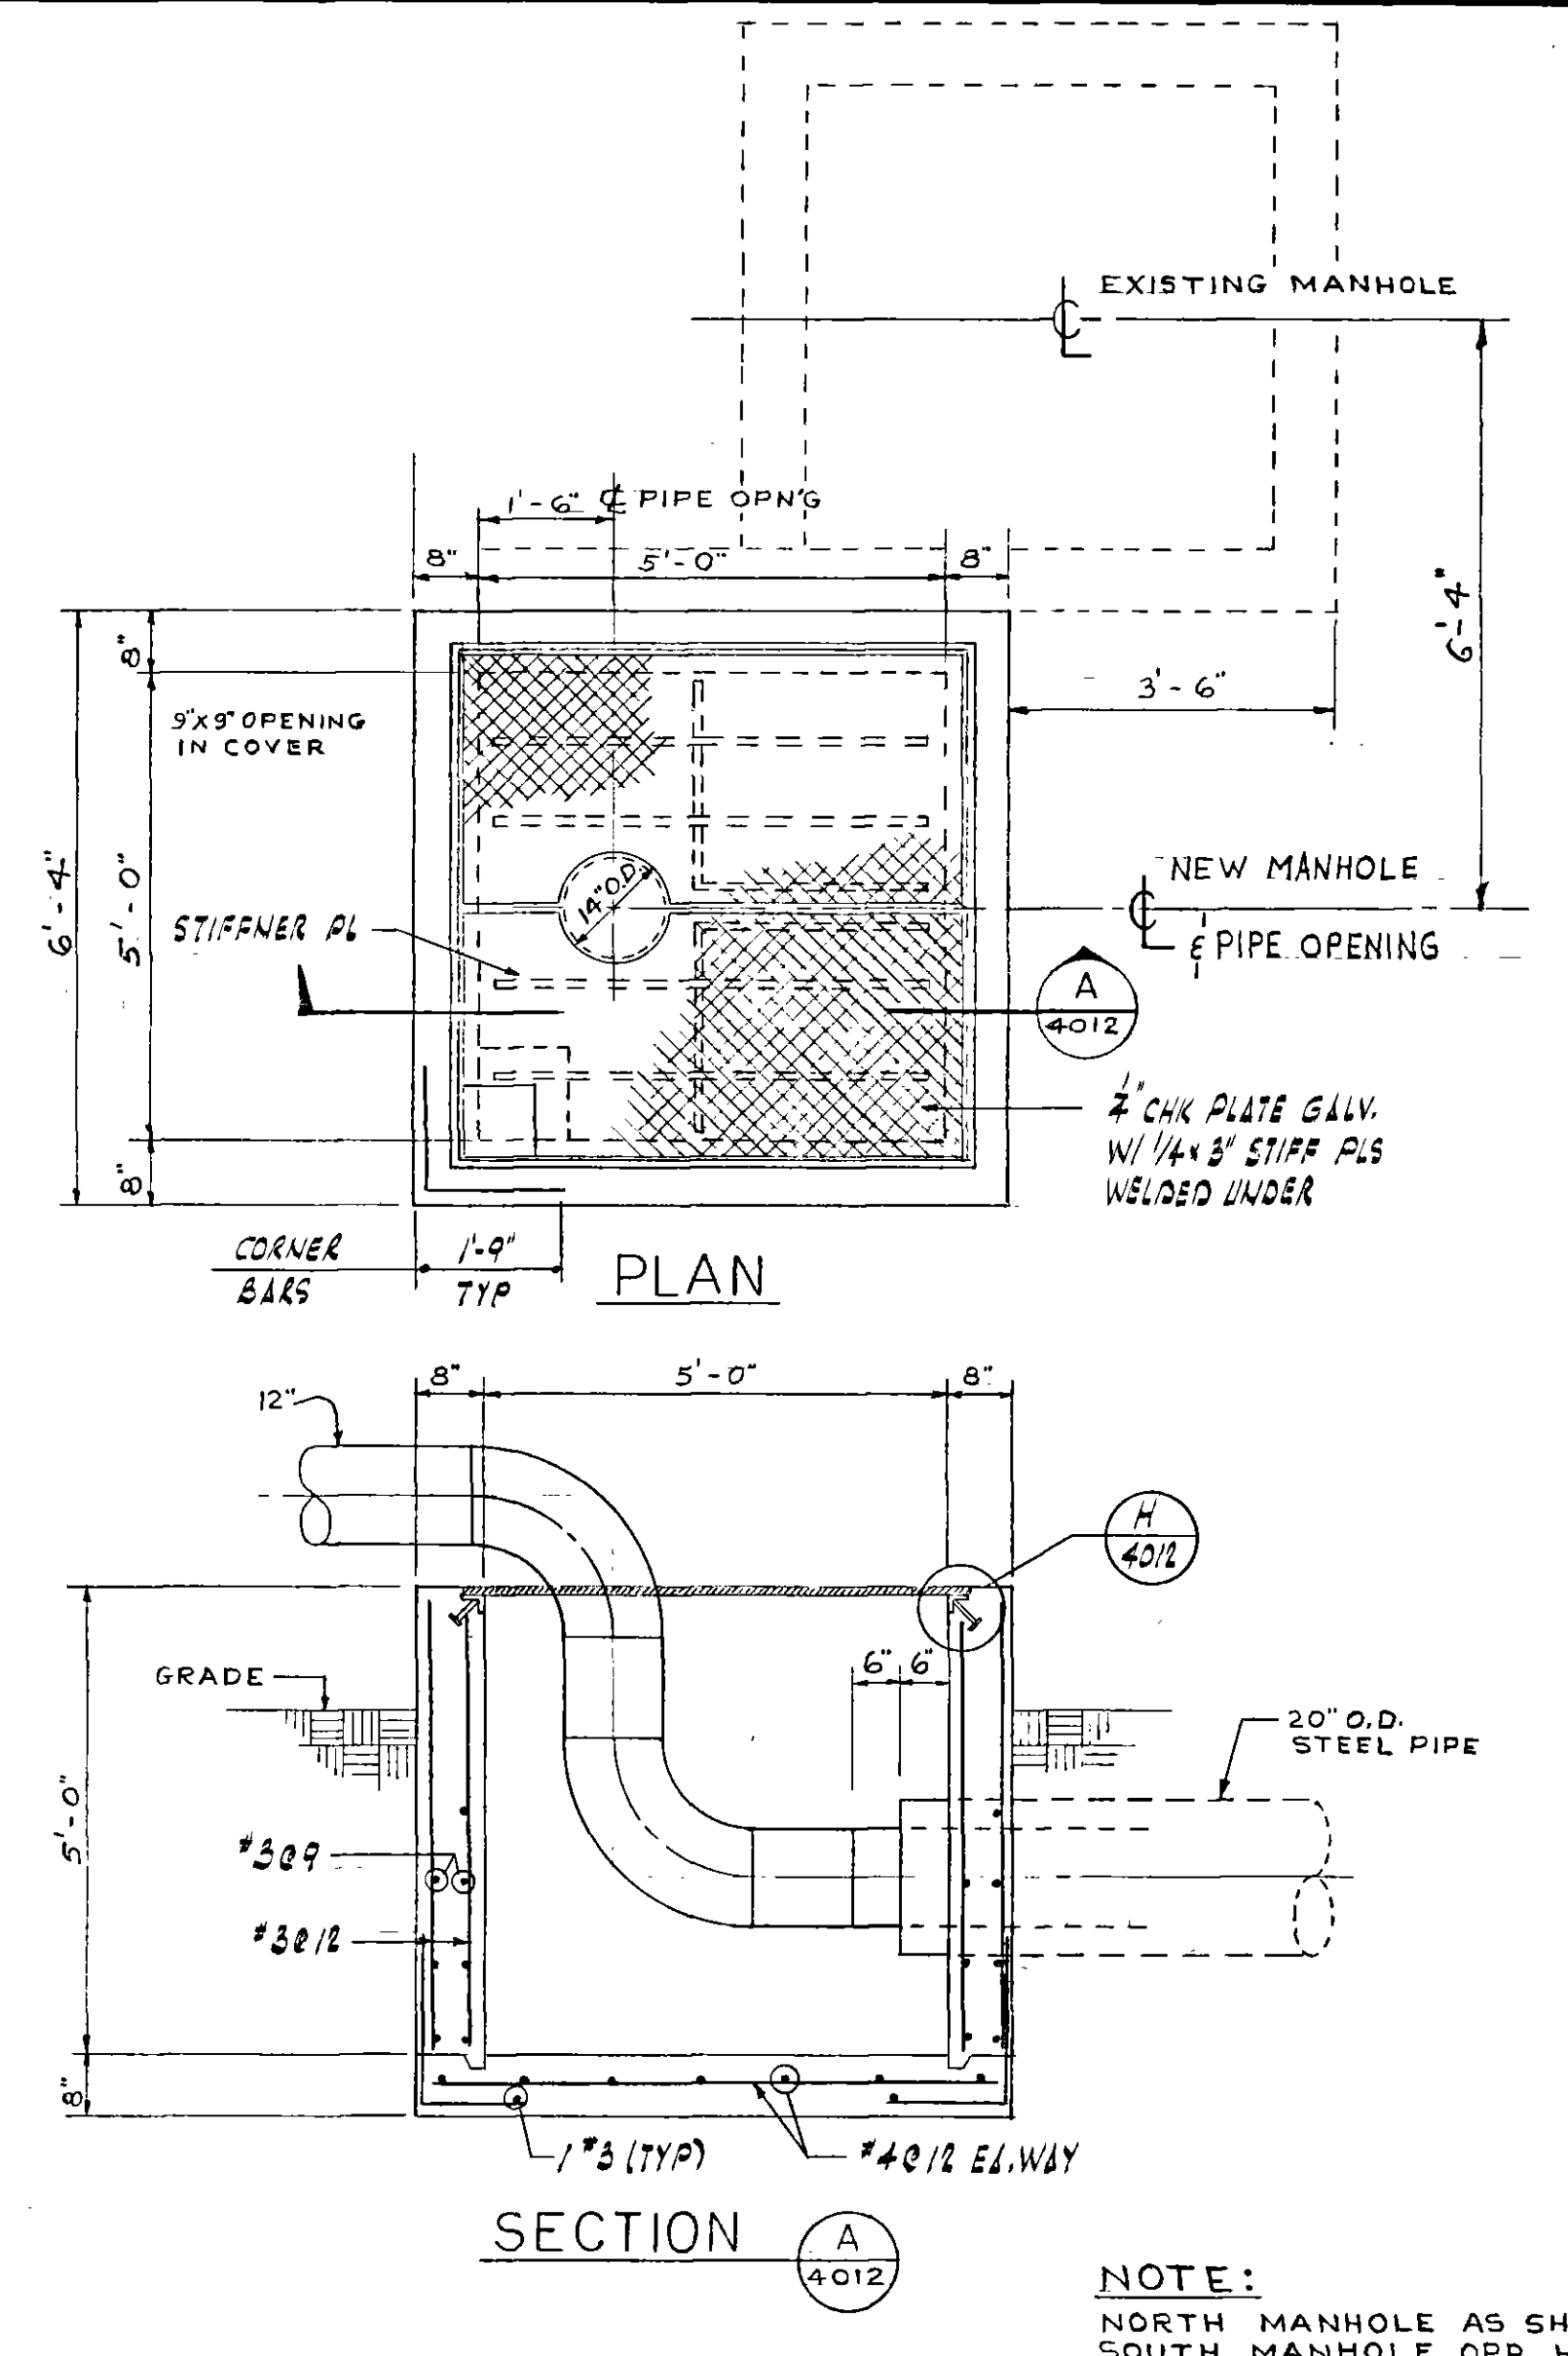


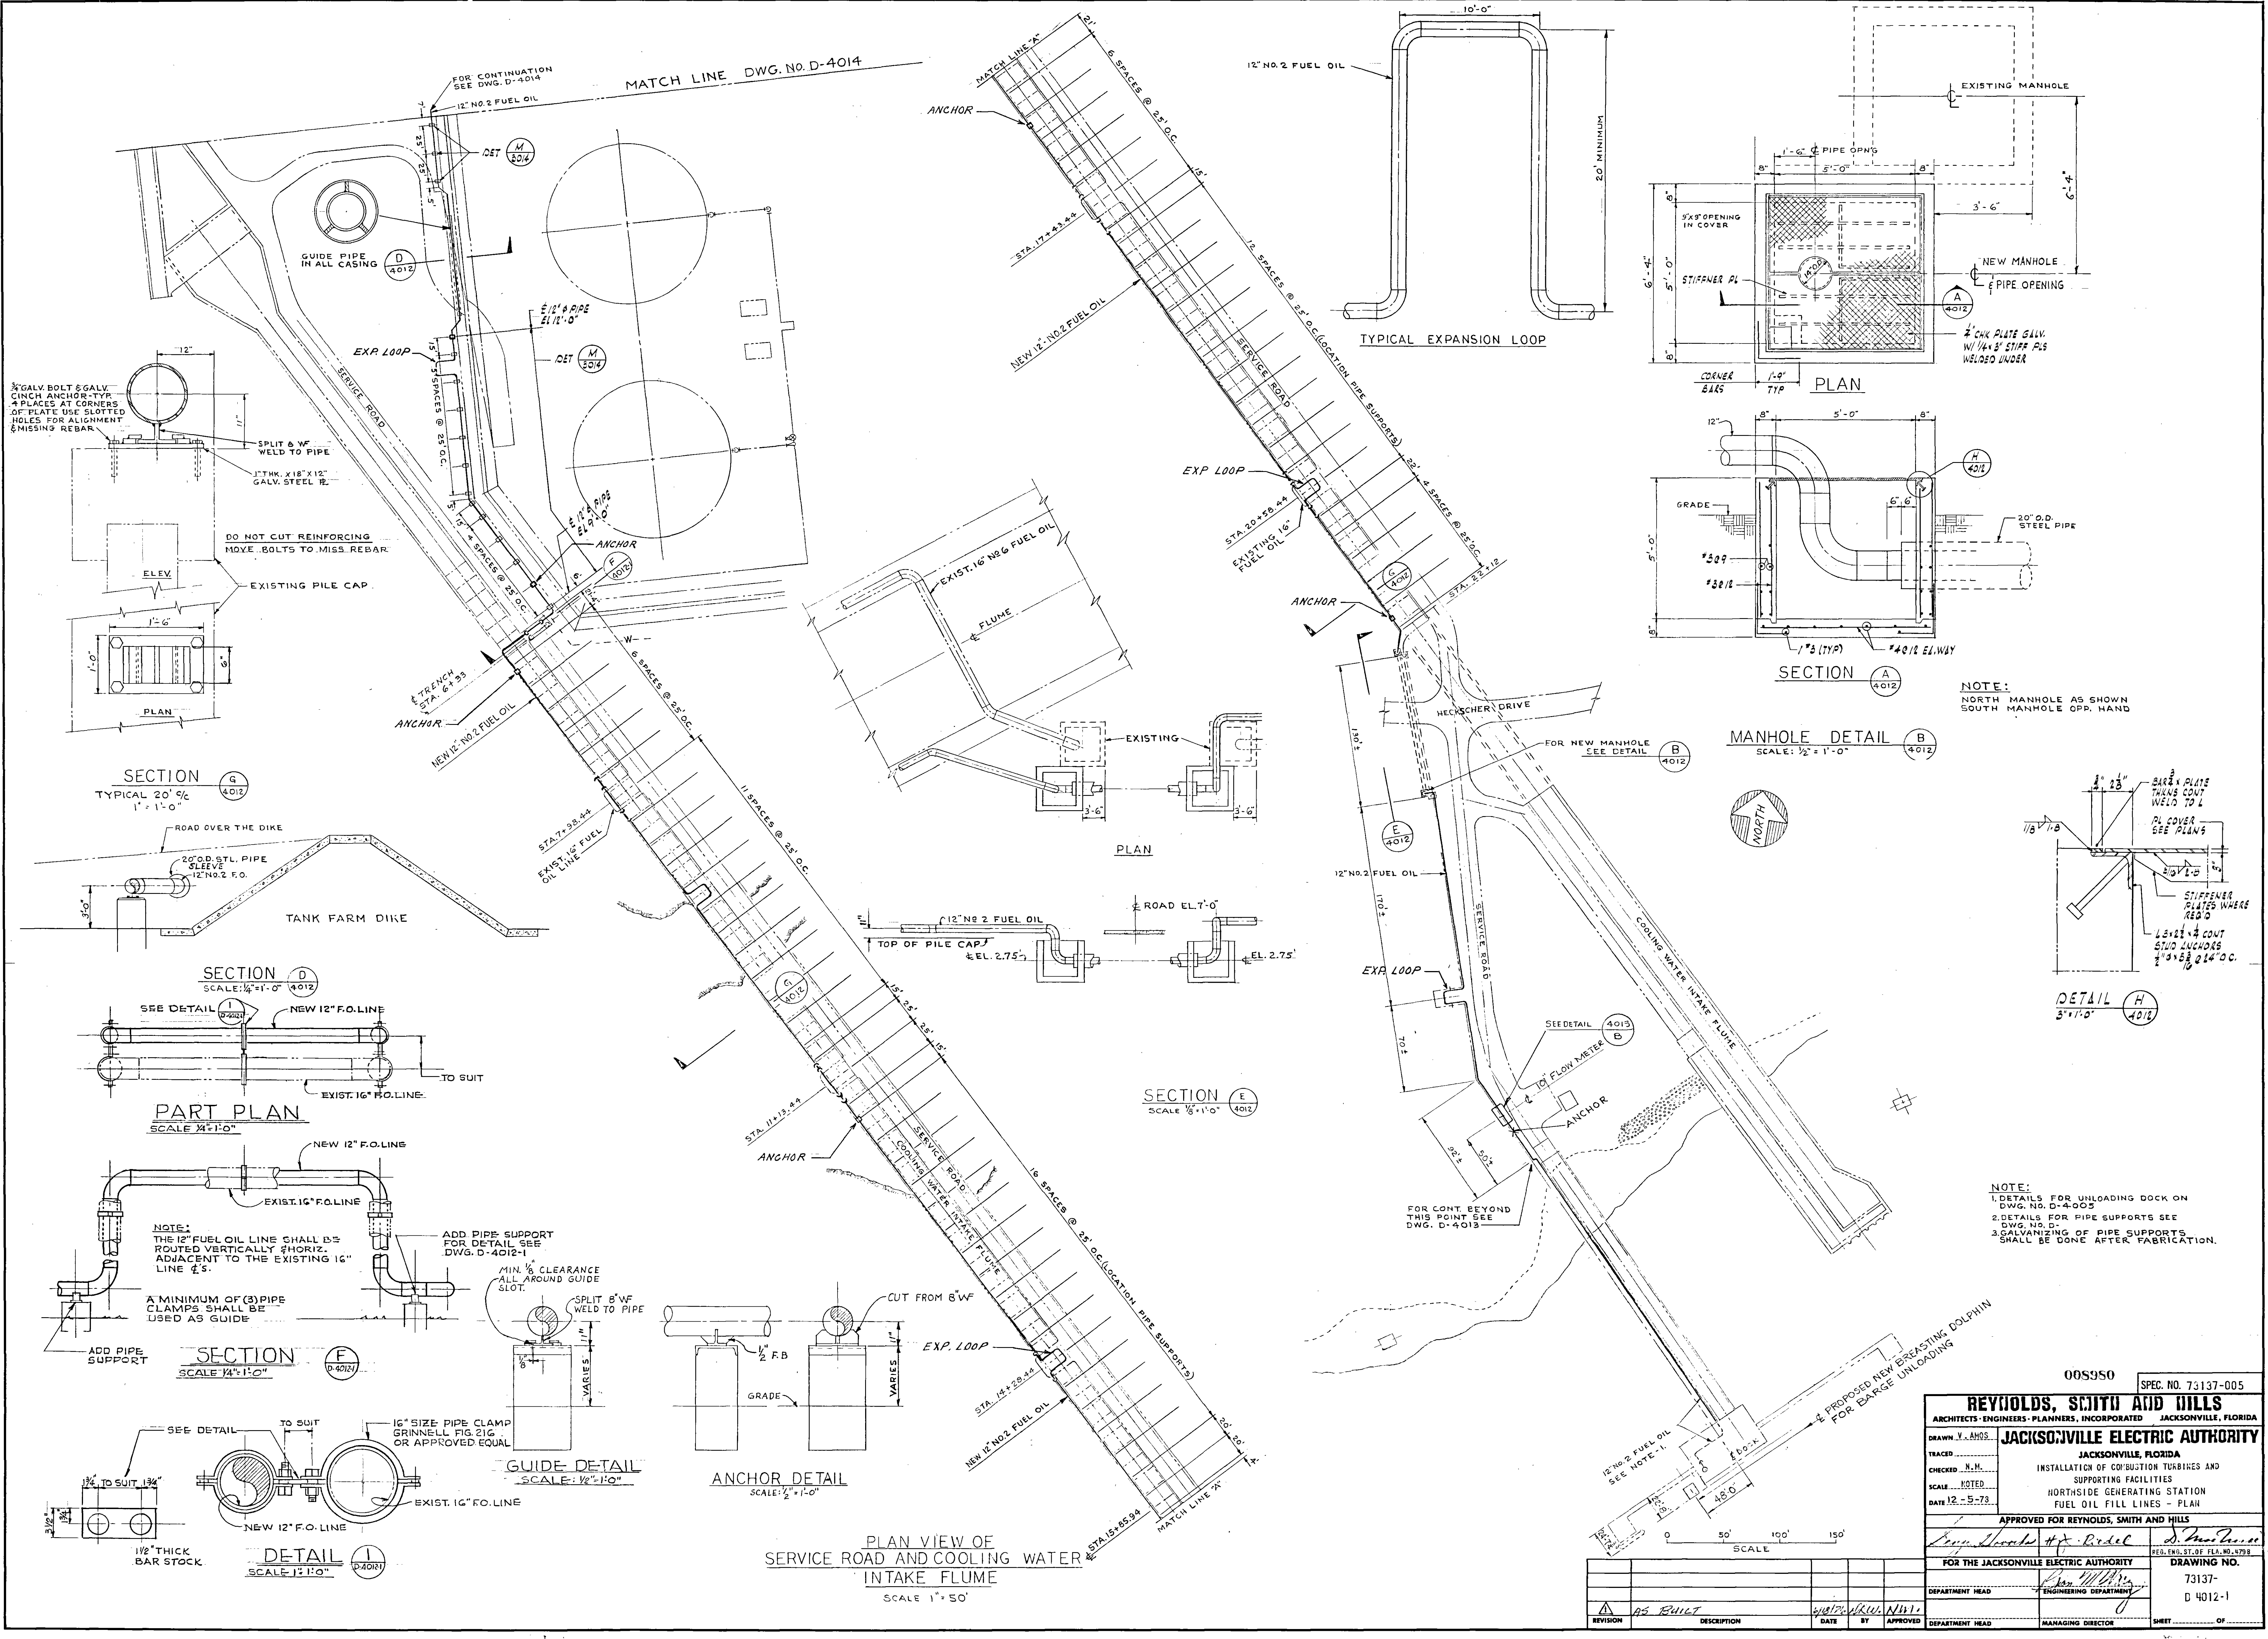

NOTE:
NORTH MANHOLE AS SHOWN
SOUTH MANHOLE OPP. HAND

MANHOLE DETAIL (B)
SCALE: 1/2\"/>

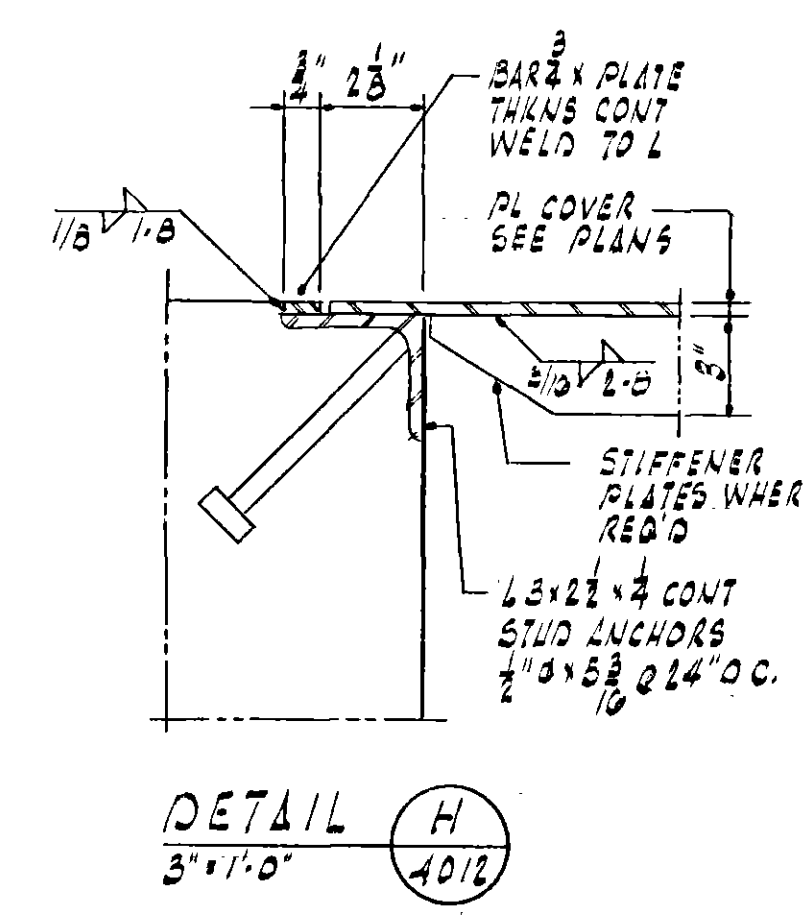

DETAIL (H)
SCALE: 3\"/>

NOTE:
1. DETAILS FOR UNLOADING DOCK ON
DWG. NO. D-4003
2. DETAILS FOR PIPE SUPPORTS SEE
DWG. NO. D-
3. GALVANIZING OF PIPE SUPPORTS
SHALL BE DONE AFTER FABRICATION.

PLAN VIEW OF
SERVICE ROAD AND COOLING WATER
INTAKE FLUME
SCALE 1\"/>

005950
SPEC. NO. 73137-005

REYNOLDS, SMITH AND HILLS
ARCHITECTS-ENGINEERS-PLANNERS, INCORPORATED JACKSONVILLE, FLORIDA


DRAWN BY: AMOS
CHECKED BY: N.M.H.
SCALE: NOTED
DATE: 12-9-73

JACKSONVILLE ELECTRIC AUTHORITY
JACKSONVILLE, FLORIDA
INSTALLATION OF COMBUSTION TURBINES AND
SUPPORTING FACILITIES
NORTHSIDE GENERATING STATION
FUEL OIL FILL LINES - PLAN

APPROVED FOR REYNOLDS, SMITH AND HILLS
FOR THE JACKSONVILLE ELECTRIC AUTHORITY
DEPARTMENT HEAD
MANAGING DIRECTOR


DRAWING NO.
73137-
D 4012-1

REVISION	DESCRIPTION	DATE	BY	APPROVED
AS BUILT				

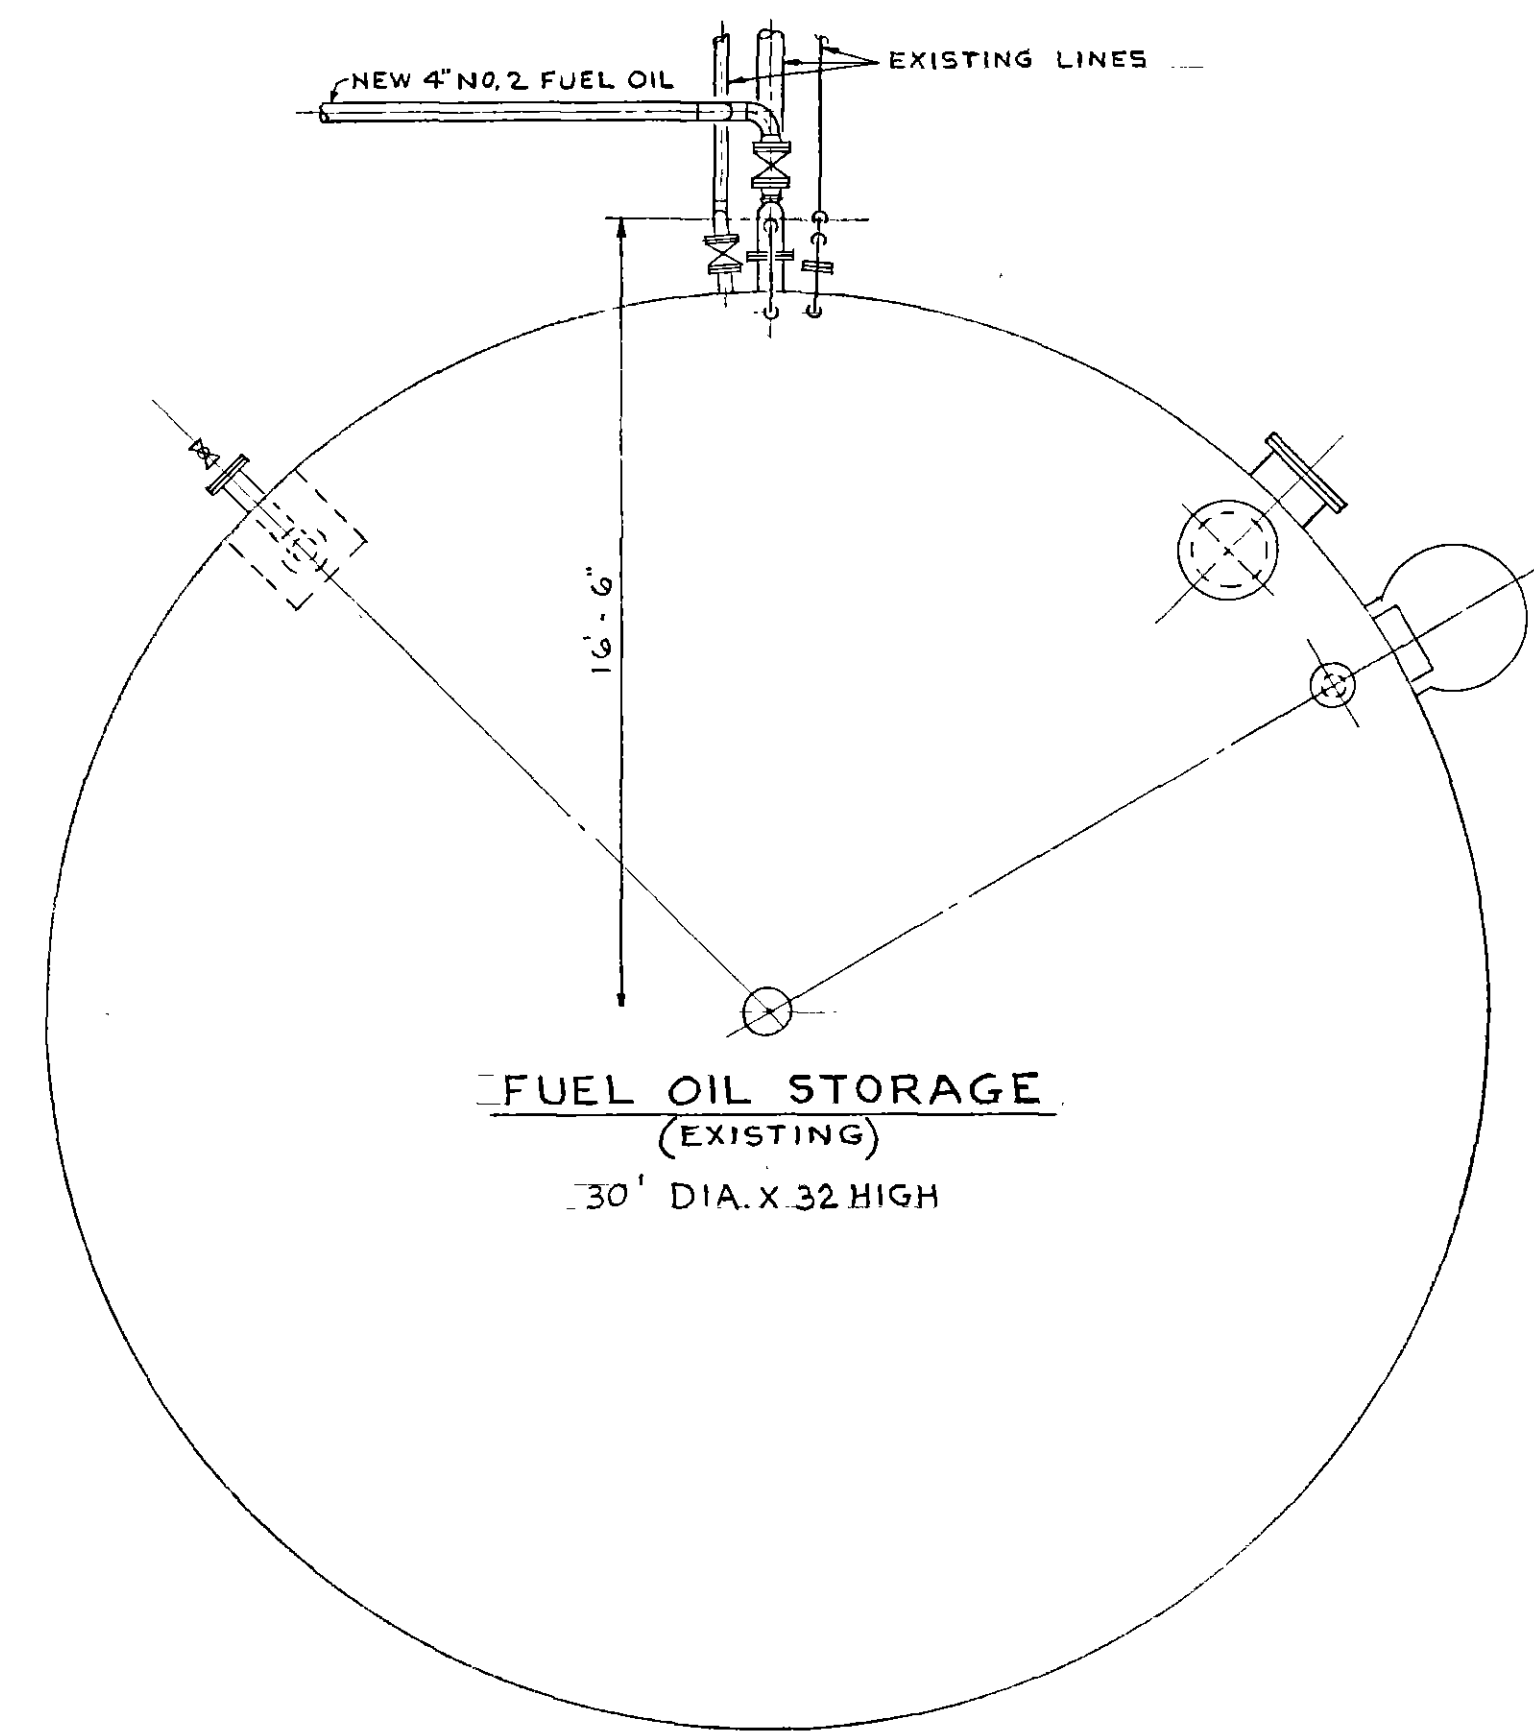


PLAN
SCALE: 1/4"=1'-0"


DETAIL A
SCALE: 1/2"=1'-0"

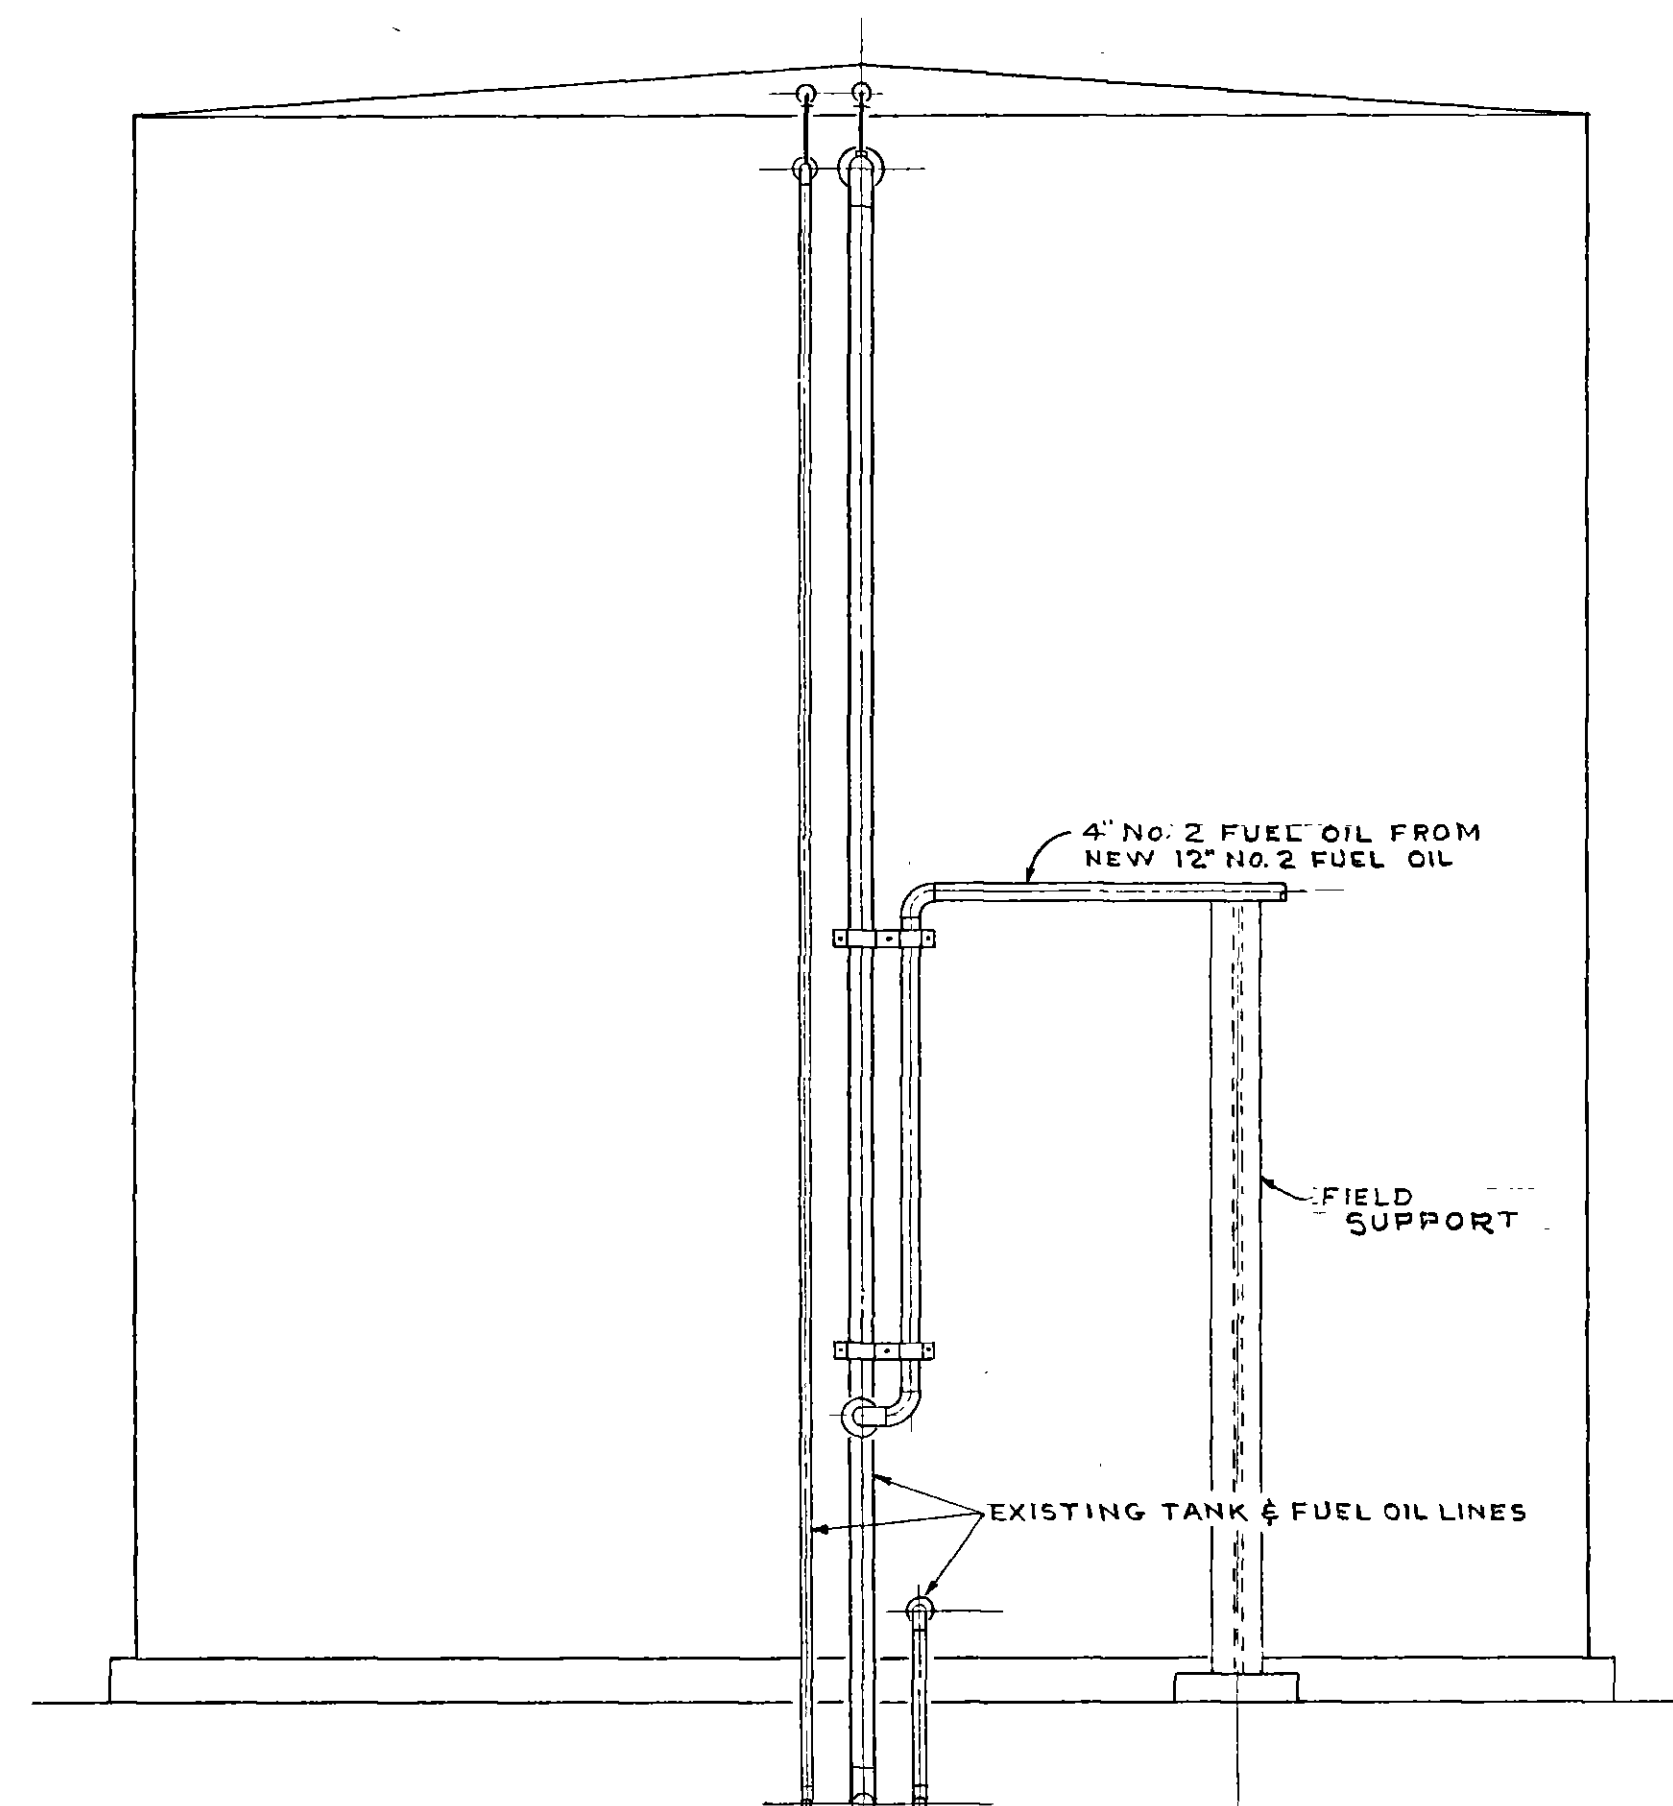


ELEV.
SCALE: 1/2"=1'-0"

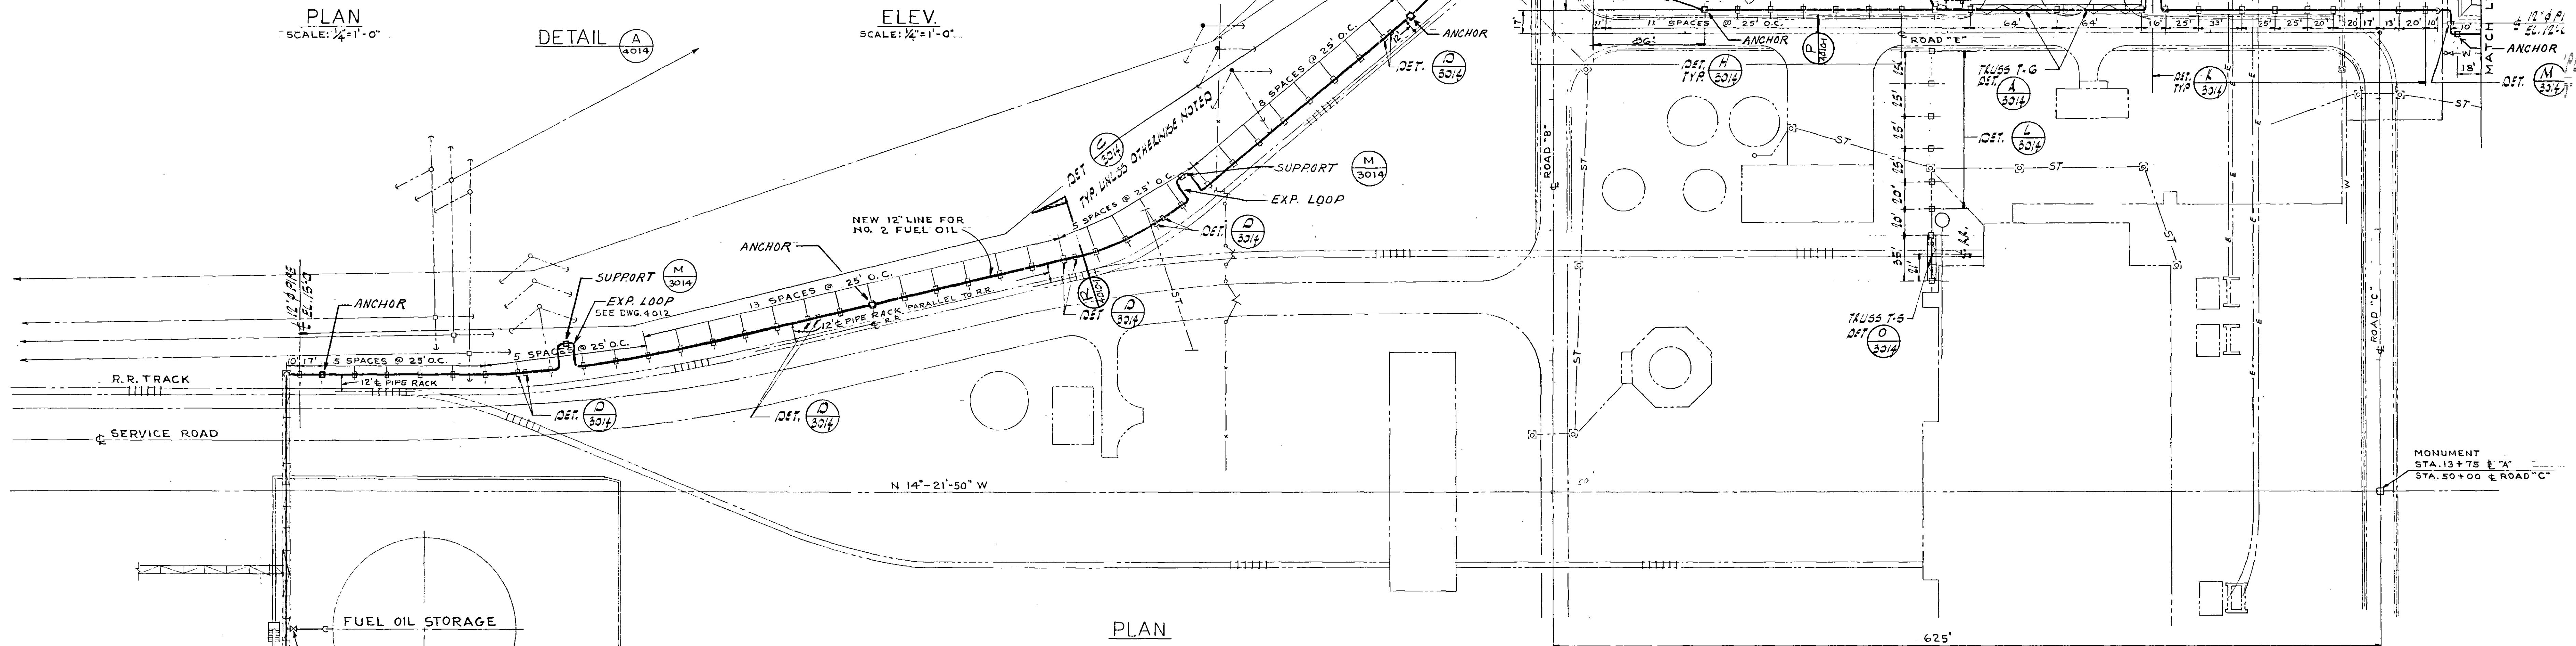


PLAN

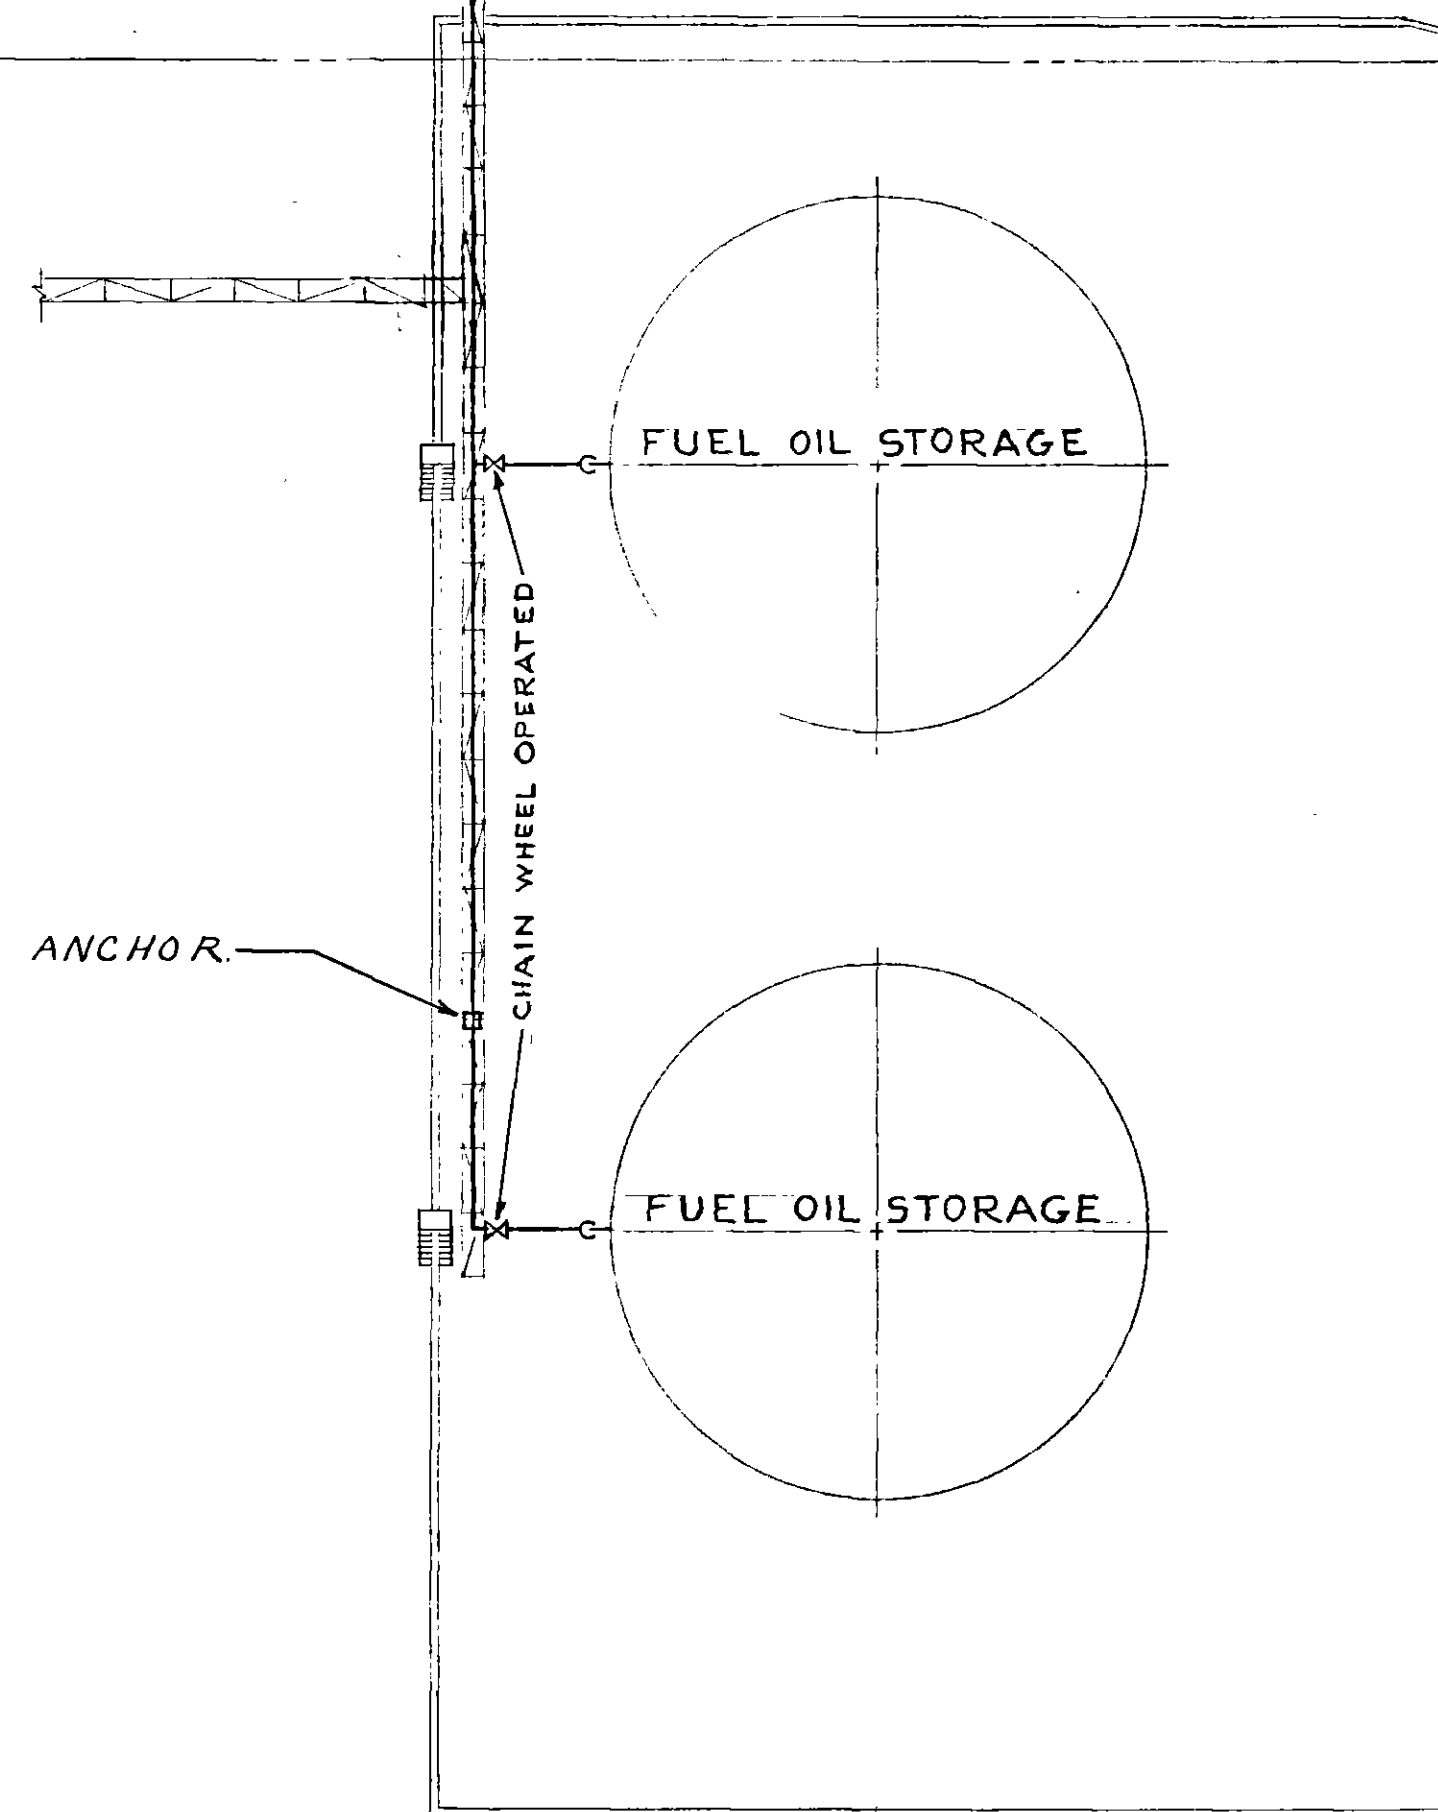


SEE PLAN FOR E.L. & OF PIPE. SLOPE UNIFORMLY

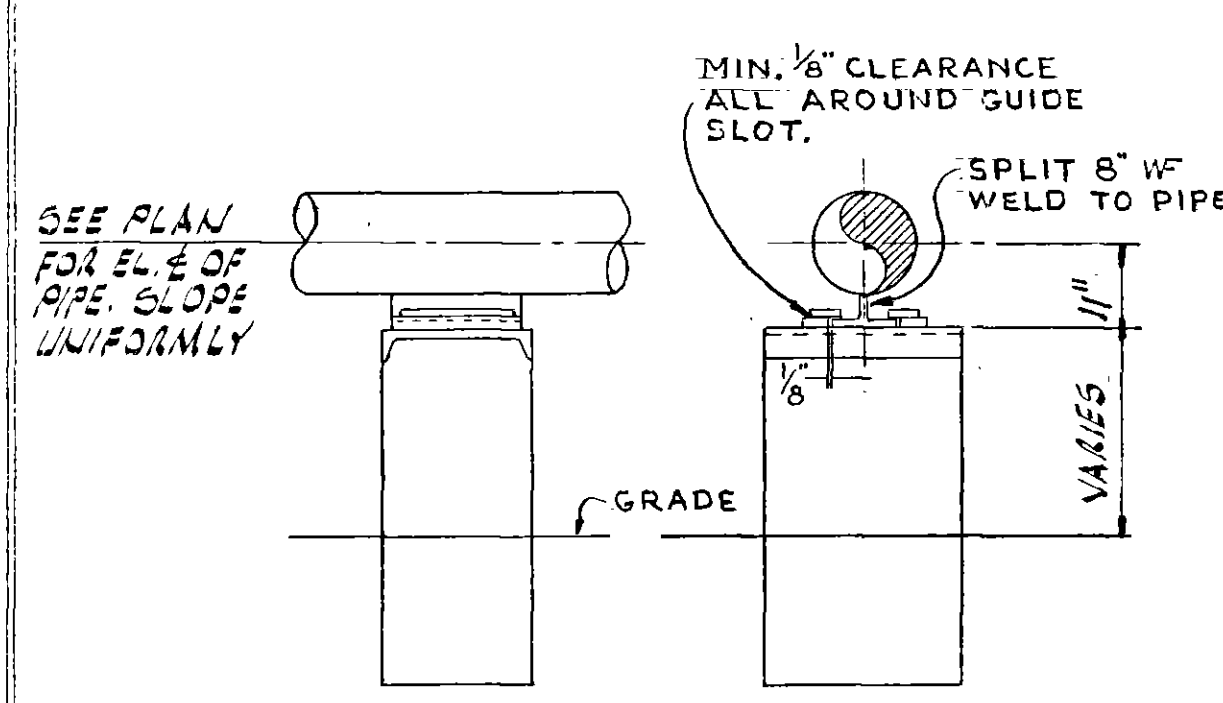

GUIDE DETAIL
SCALE: 1/2"=1'-0"

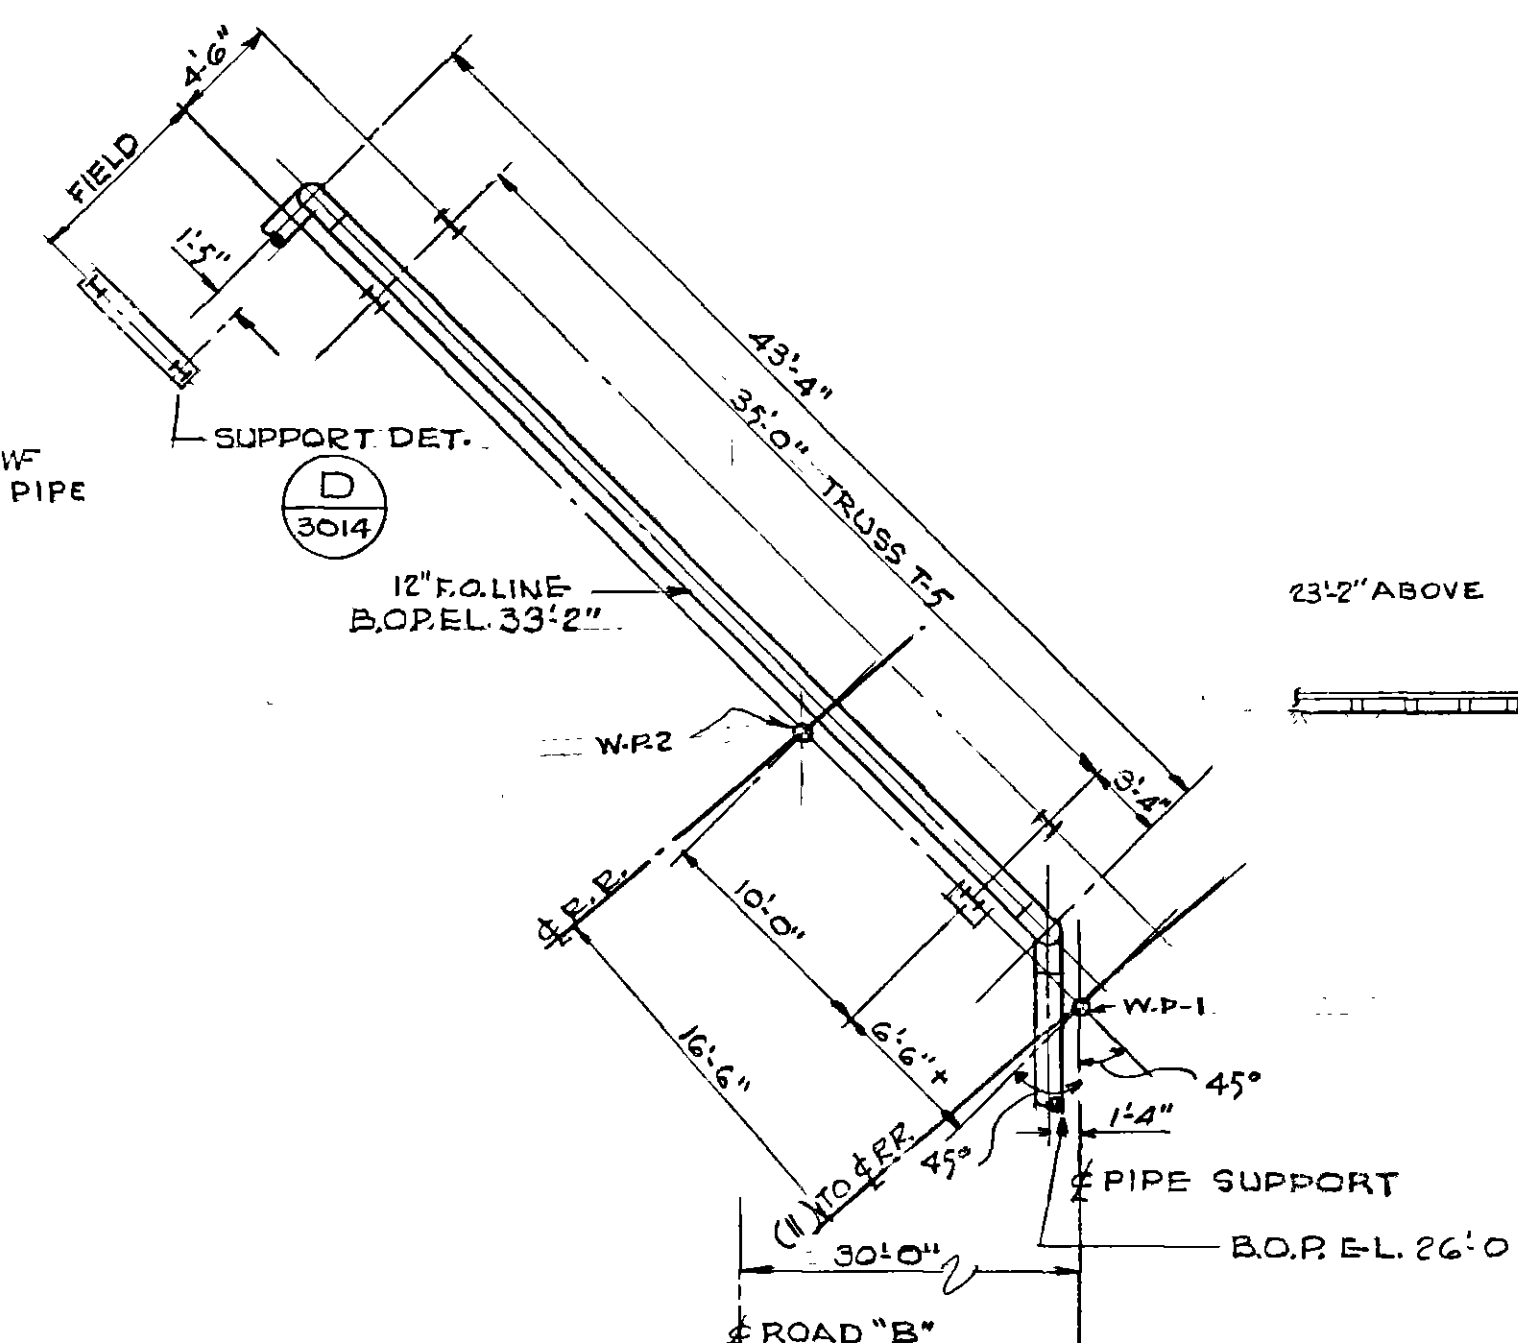

ENLARGED PLAN
12" F.O. LINE AT TRUSS T-5
SCALE: 1/8"=1'-0"

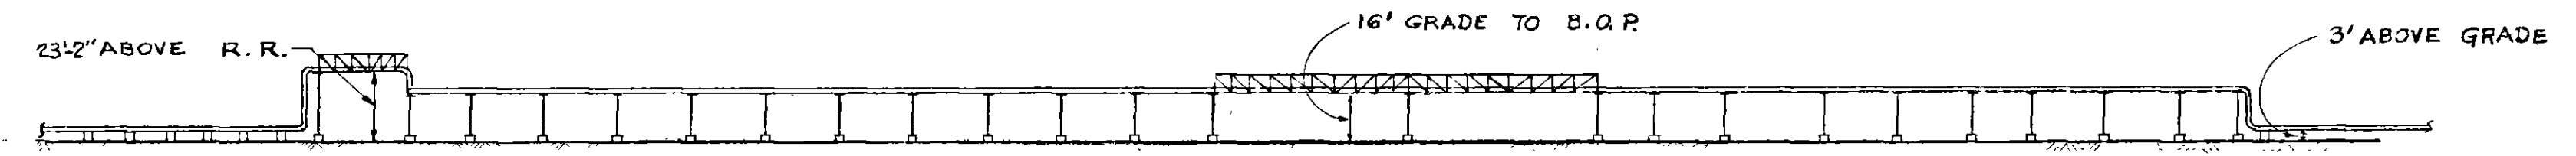


PART ELEV.

NOTE
SEE R.S. & H. DWG. D-4012 FOR EXPANSION LOOP

008952 SPEC. NO. 73137-00









REYNOLDS, SMITH AND HILLS ARCHITECTS-ENGINEERS-PLANNERS, INCORPORATED JACKSONVILLE, FLORIDA		JACKSONVILLE ELECTRIC AUTHORITY	
DRAWN: E.A.		JACKSONVILLE, FLORIDA	
TRACED: N.M.		INSTALLATION OF COMBUSTION TURBINES AND SUPPORTING FACILITIES	
CHECKED: N.M.		NORTHSHORE GENERATING STATION	
SCALE: 1/2"=50'		FUEL OIL LINE PLAN & SECTIONS	
DATE: 12-5-73		APPROVED FOR REYNOLDS, SMITH AND HILLS	
FOR THE JACKSONVILLE ELECTRIC AUTHORITY		DRAWING NO. 73137-04014-1	
DEPARTMENT HEAD		MANAGING DIRECTOR	
REVISION		SHEET	


REVISION	DESCRIPTION	DATE	BY	APPROVED
1	AS BUILT	12-21-73	V.G.A.	N.M.
2	ENG'D O.M.S. FROM FUEL PIPE SUPPORT TO R.R. TO 12"			

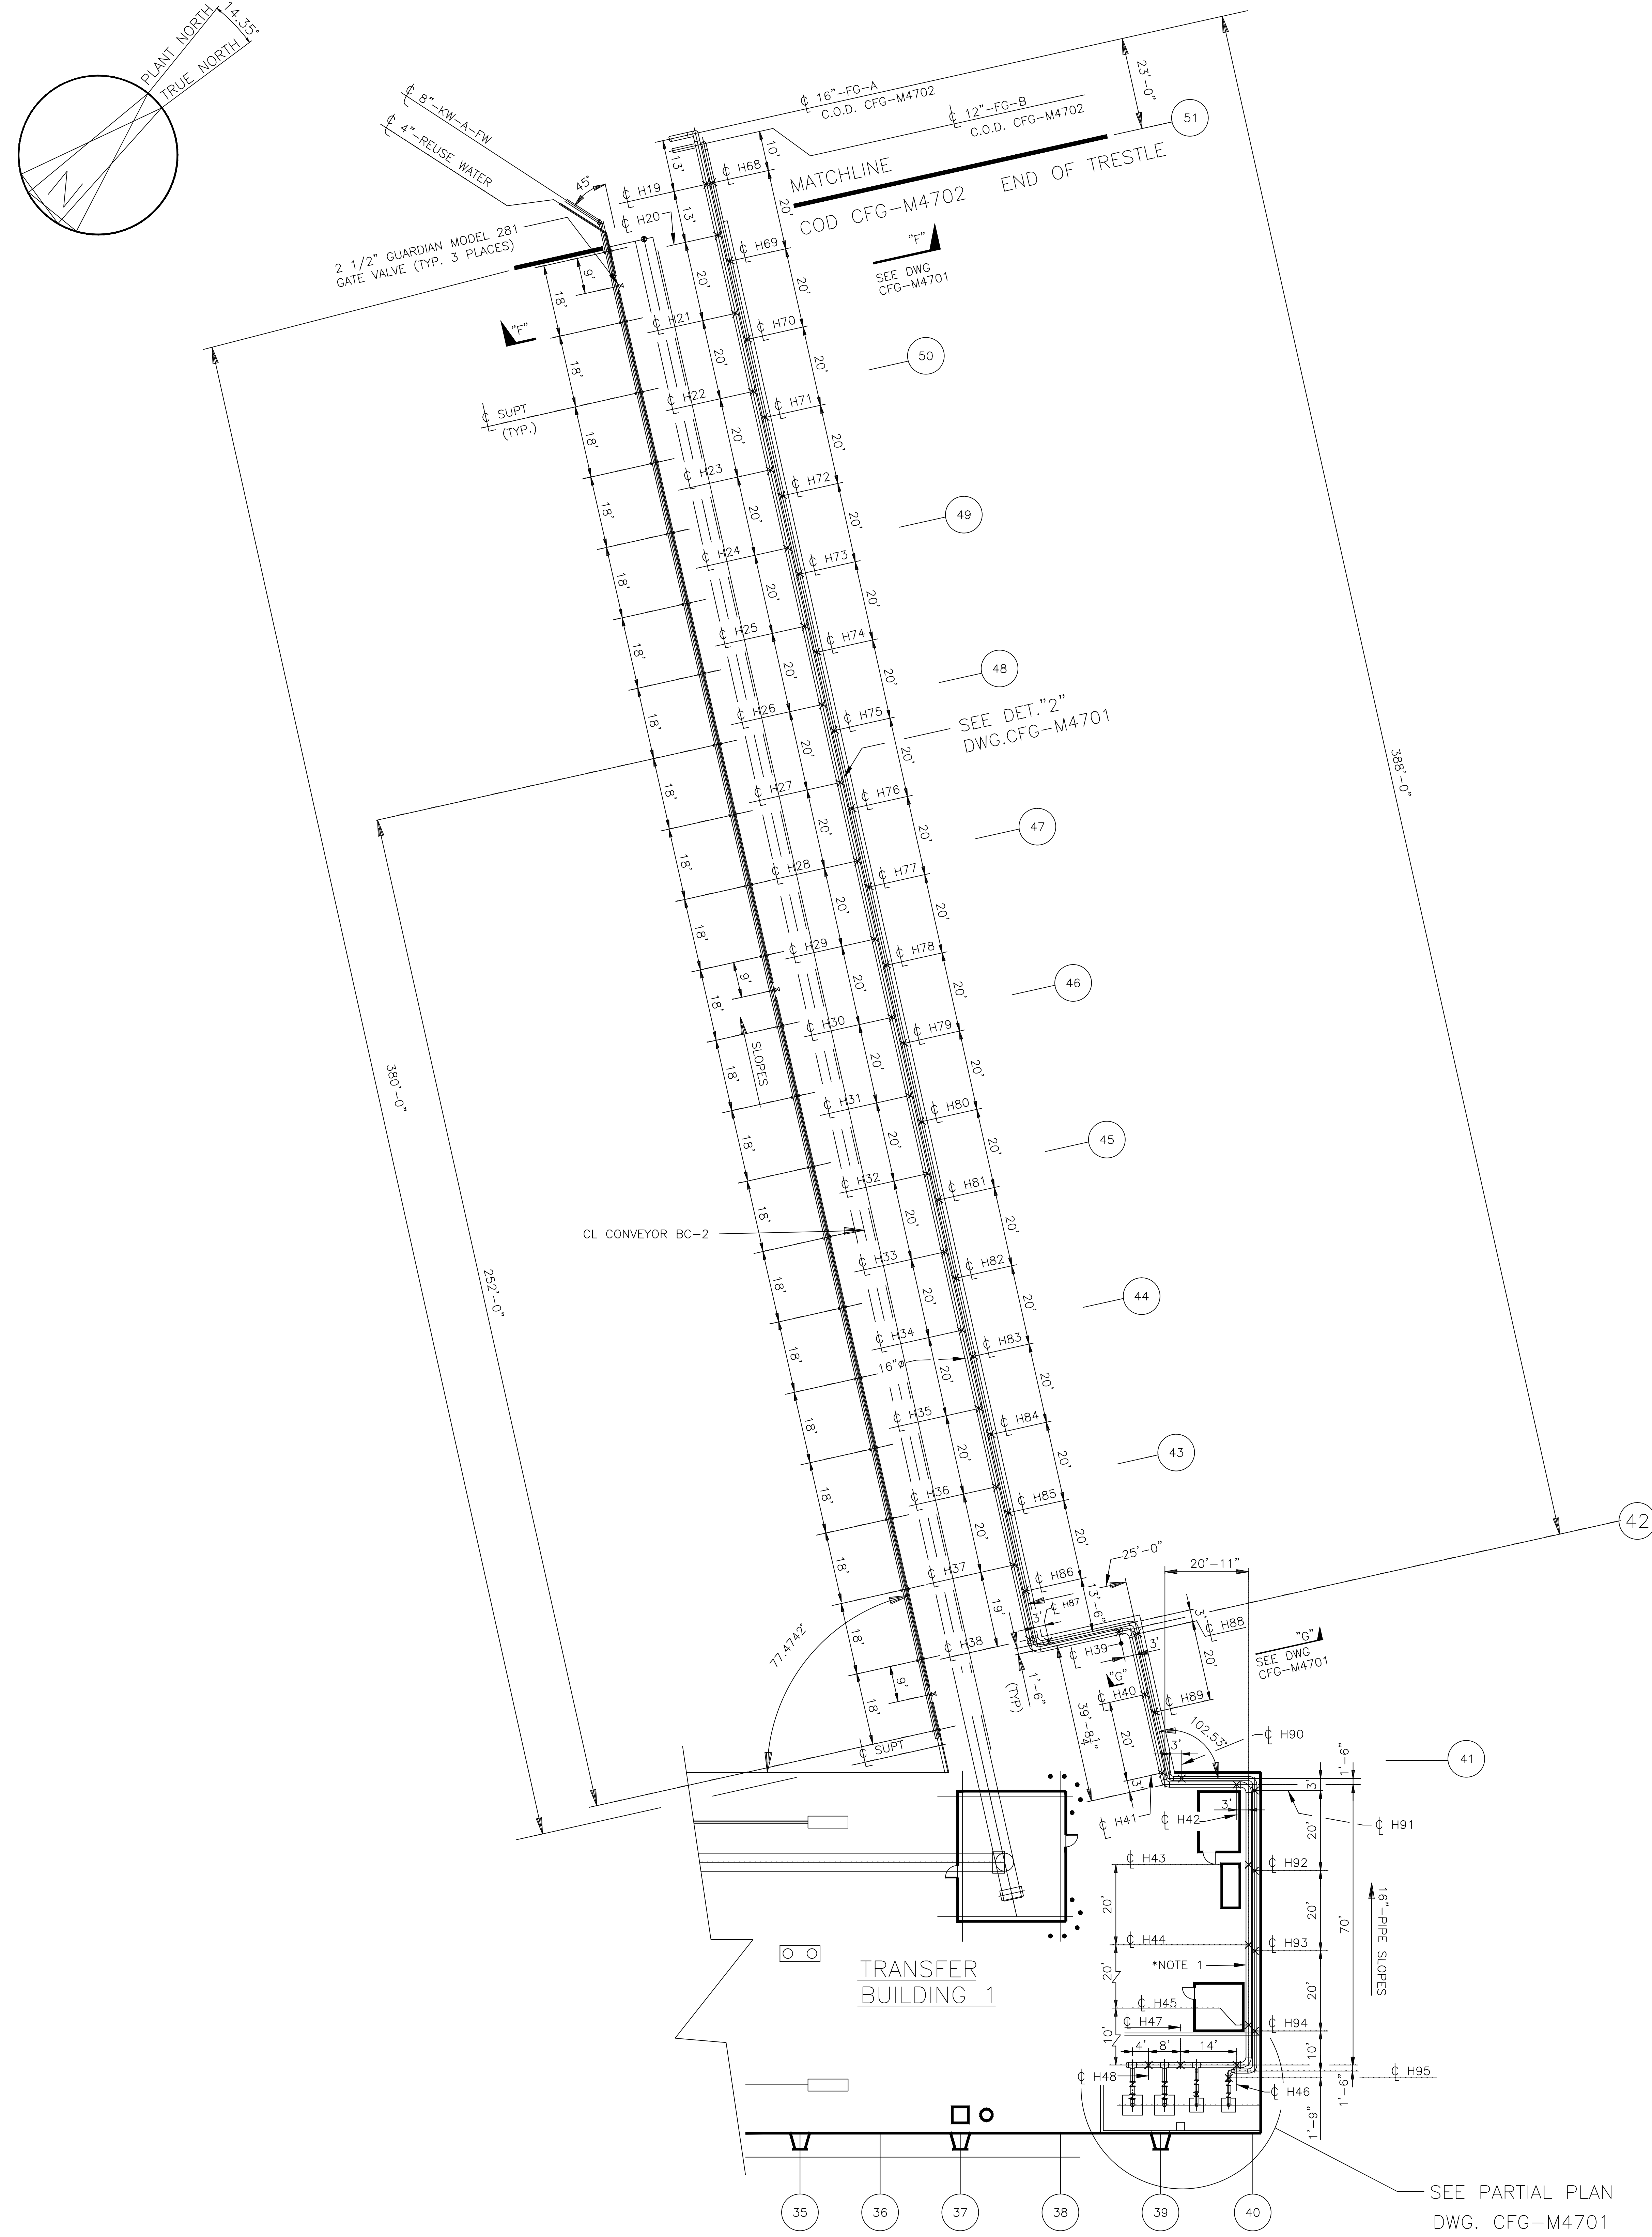


PIPING PLAN

SCALE: 1"=20'

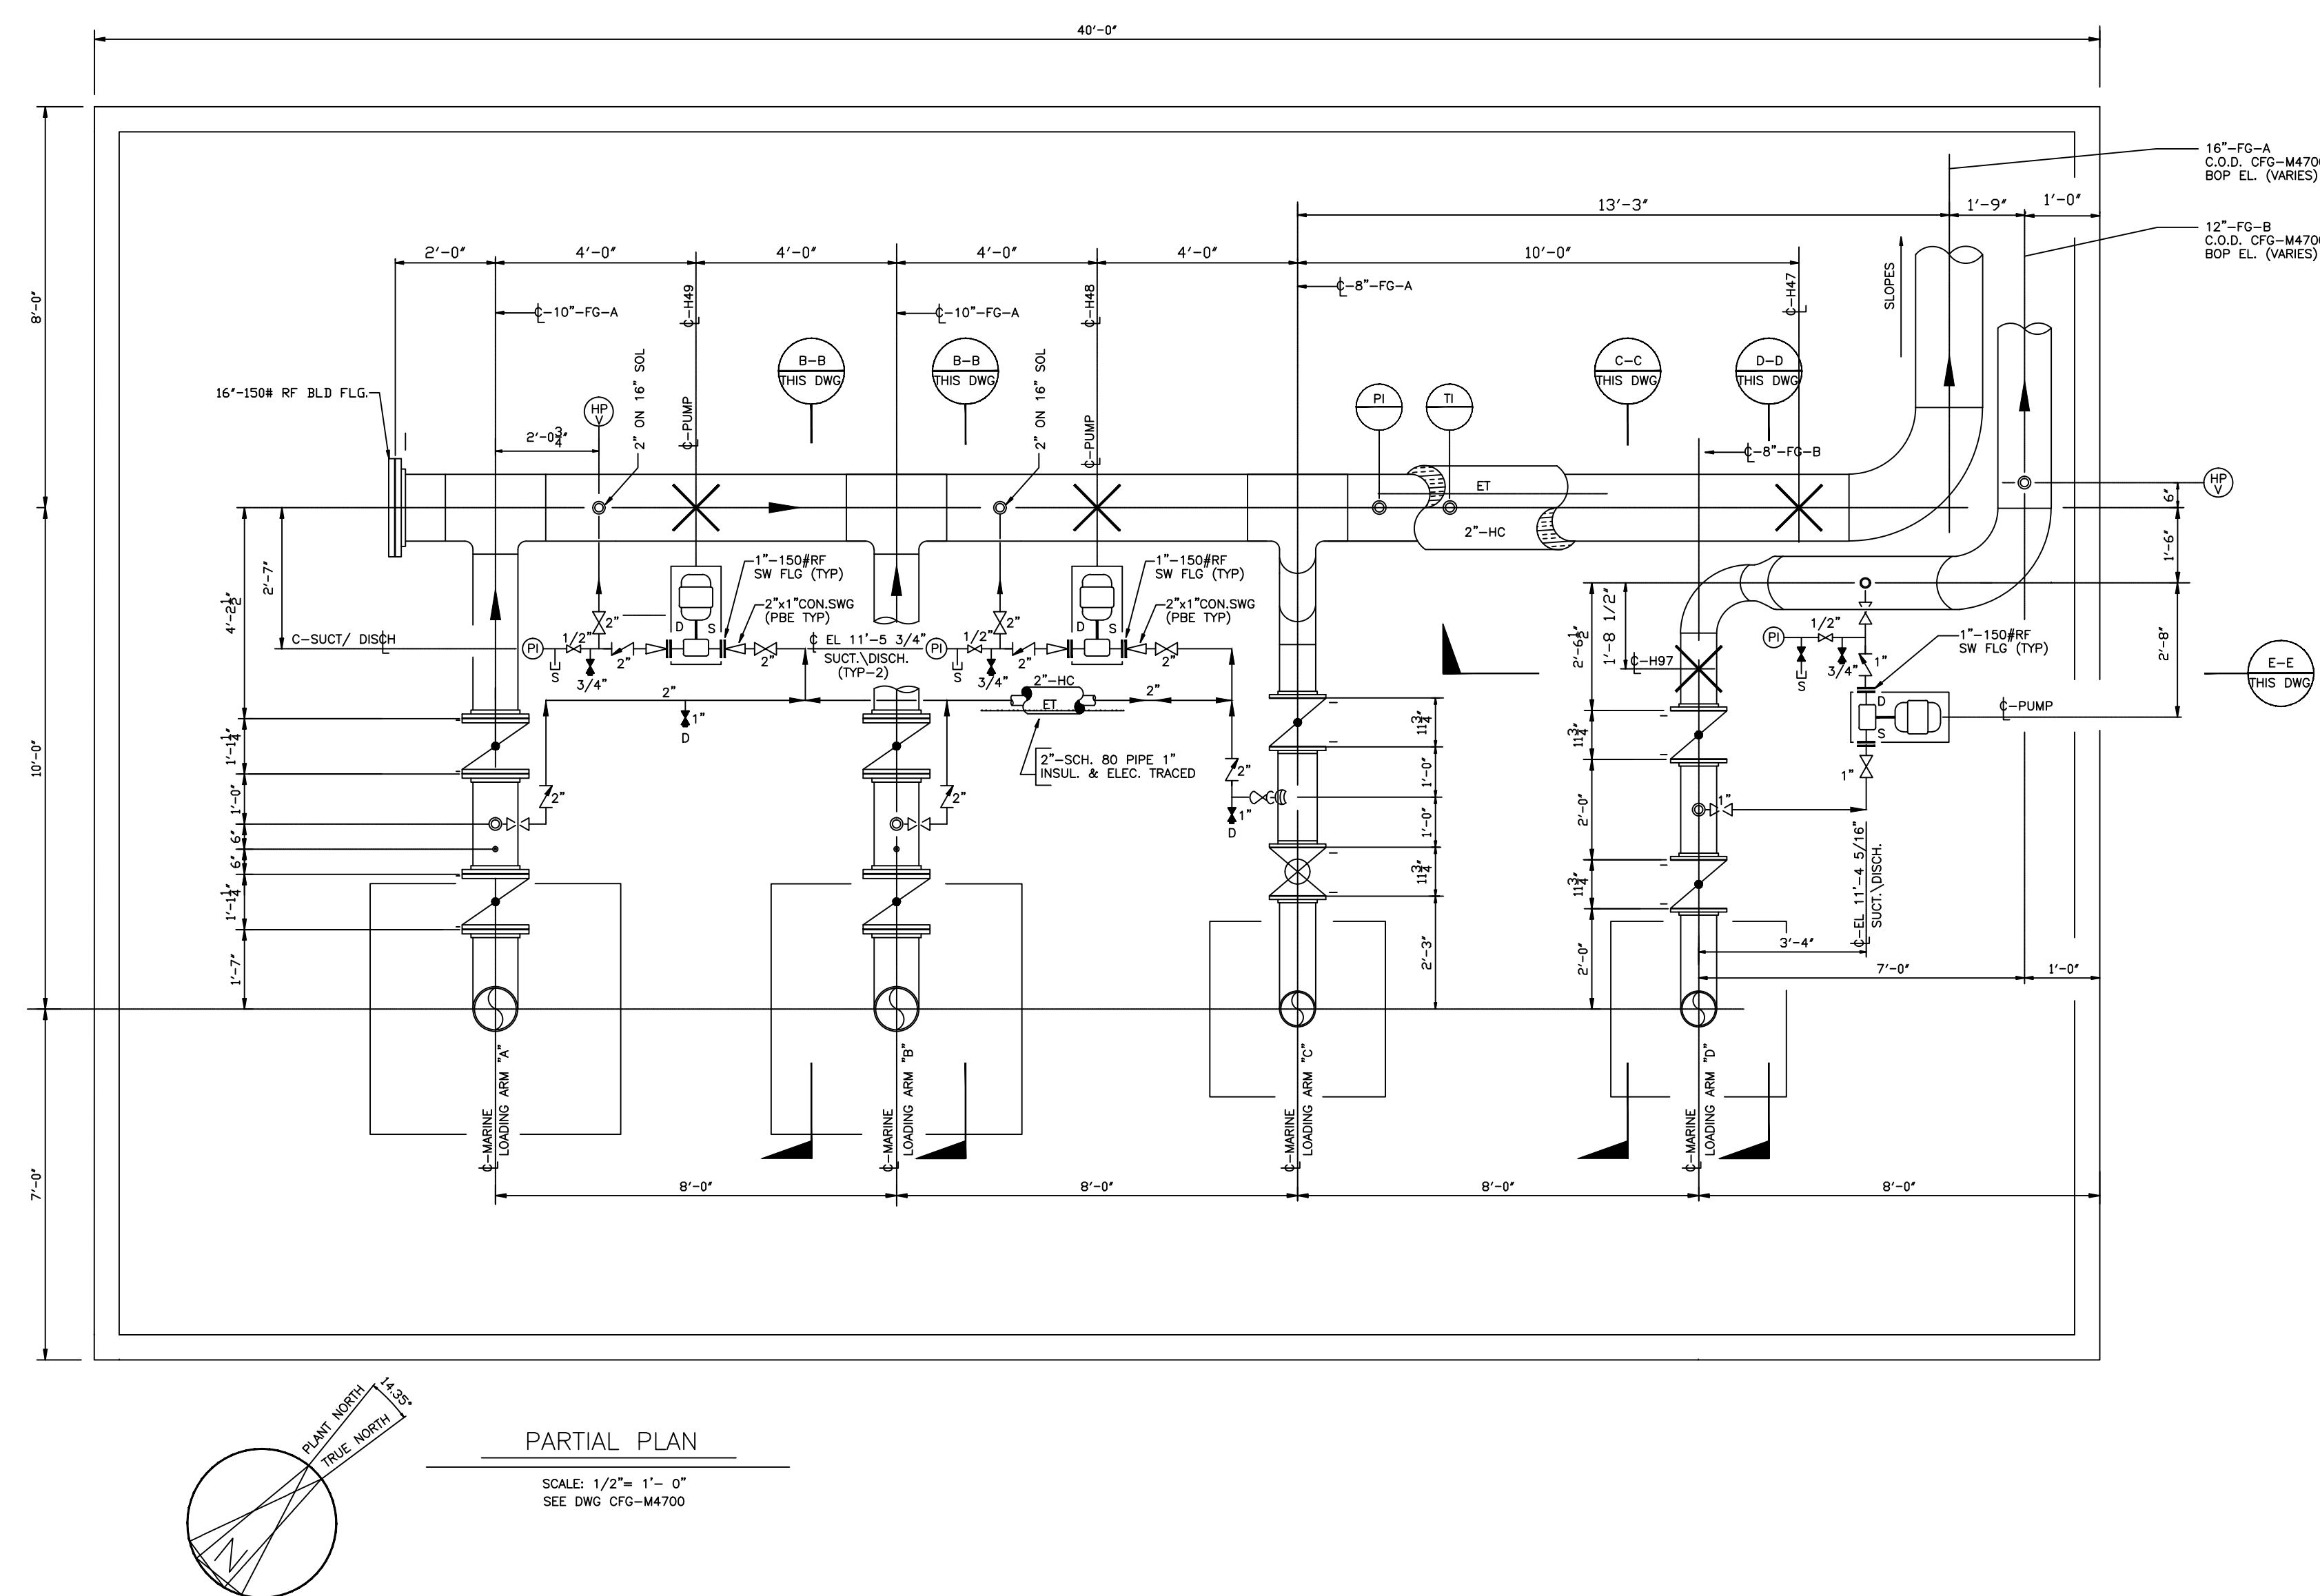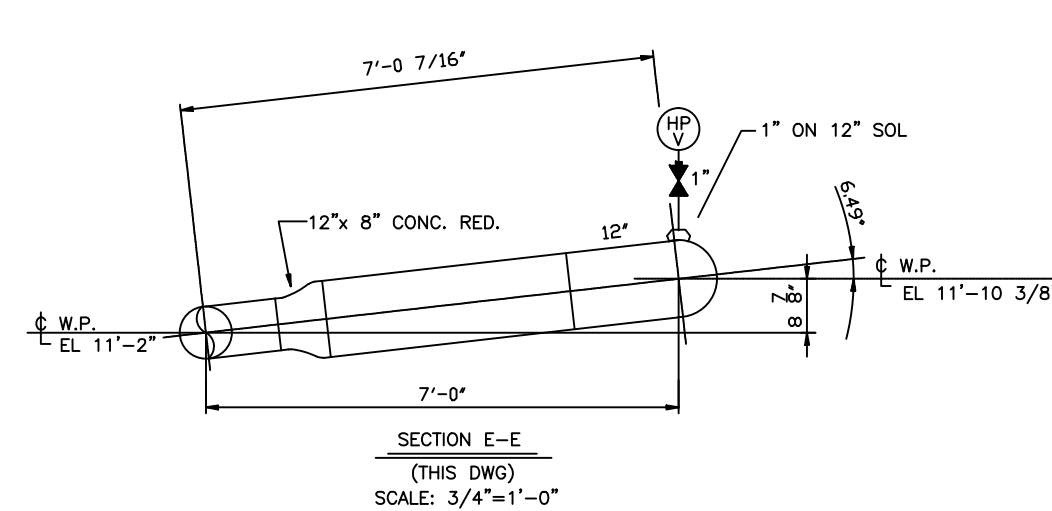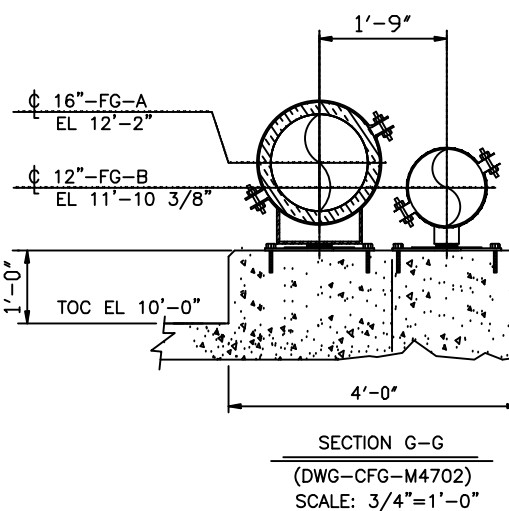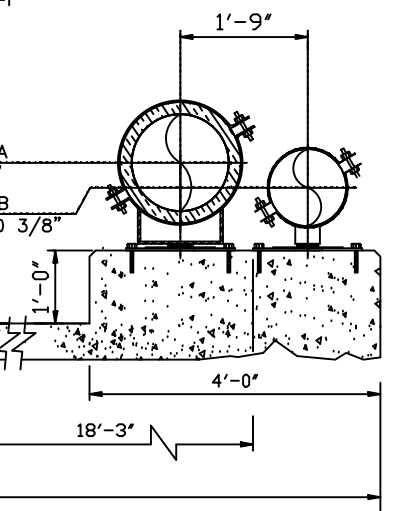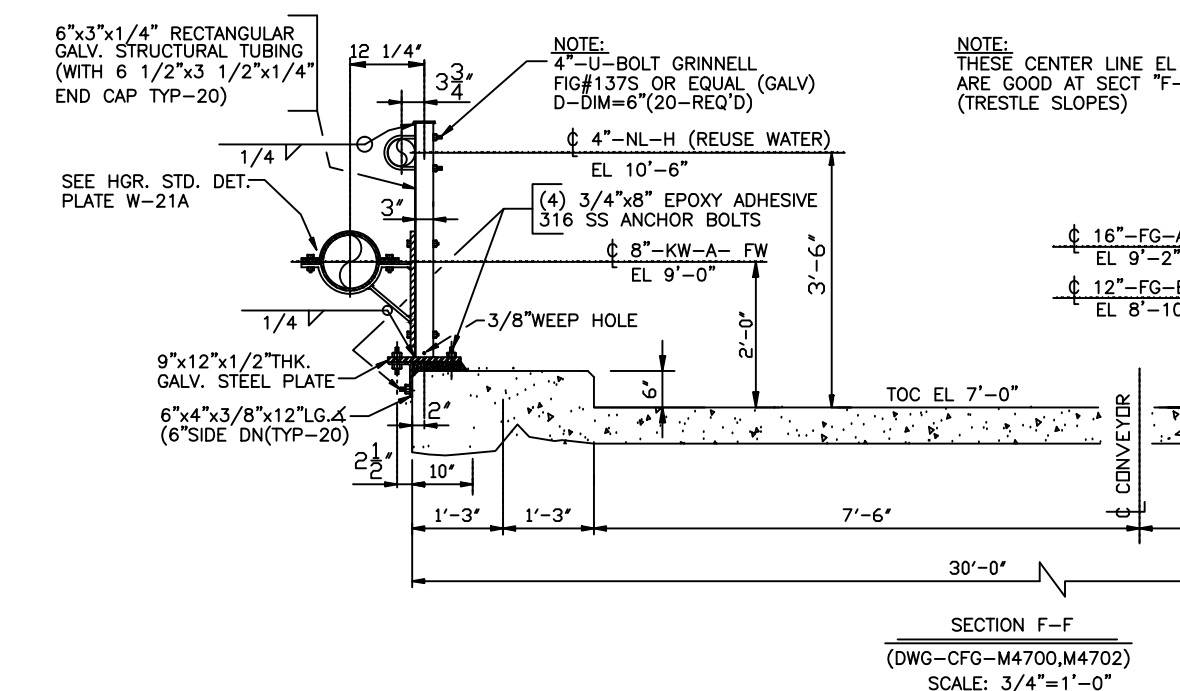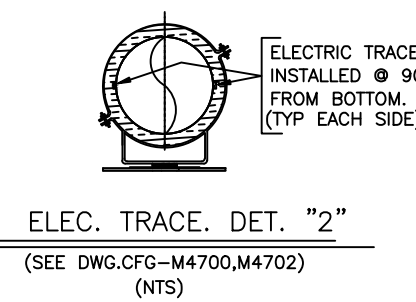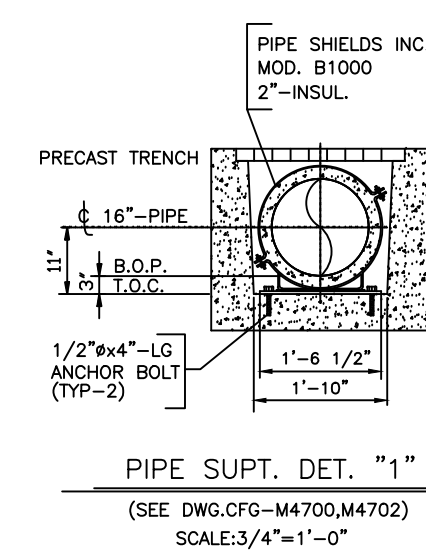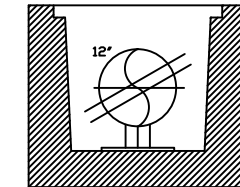

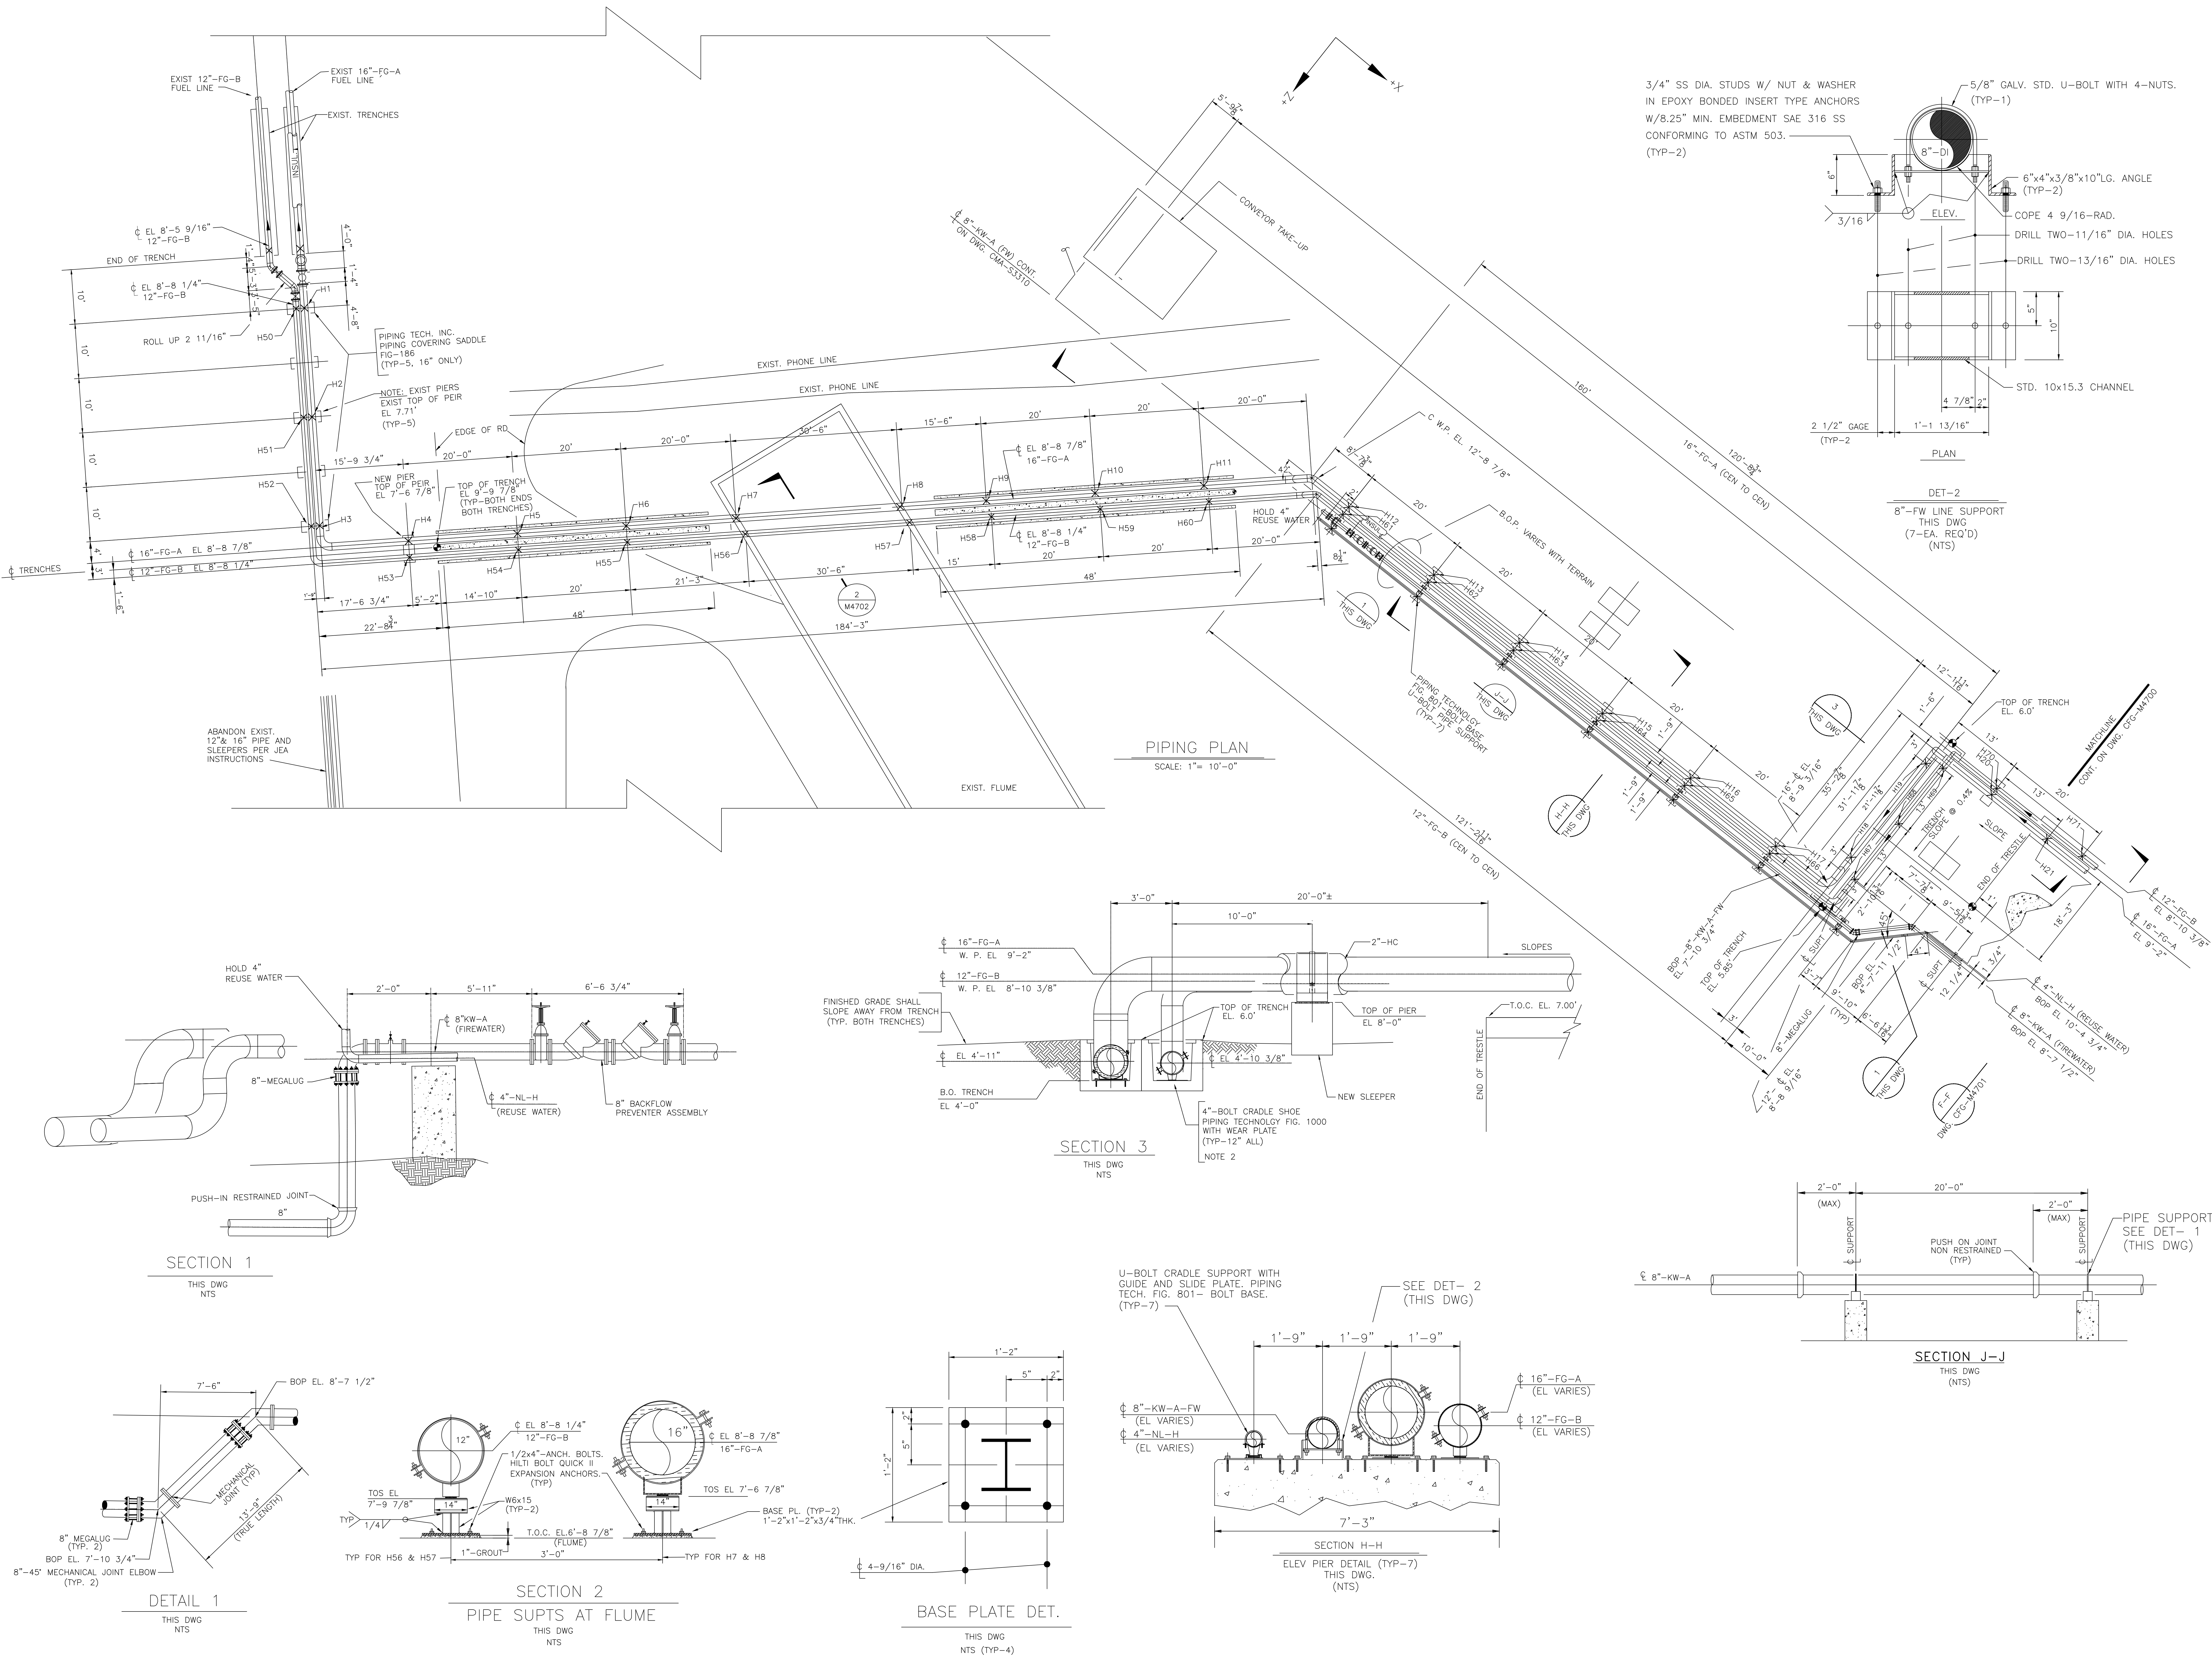

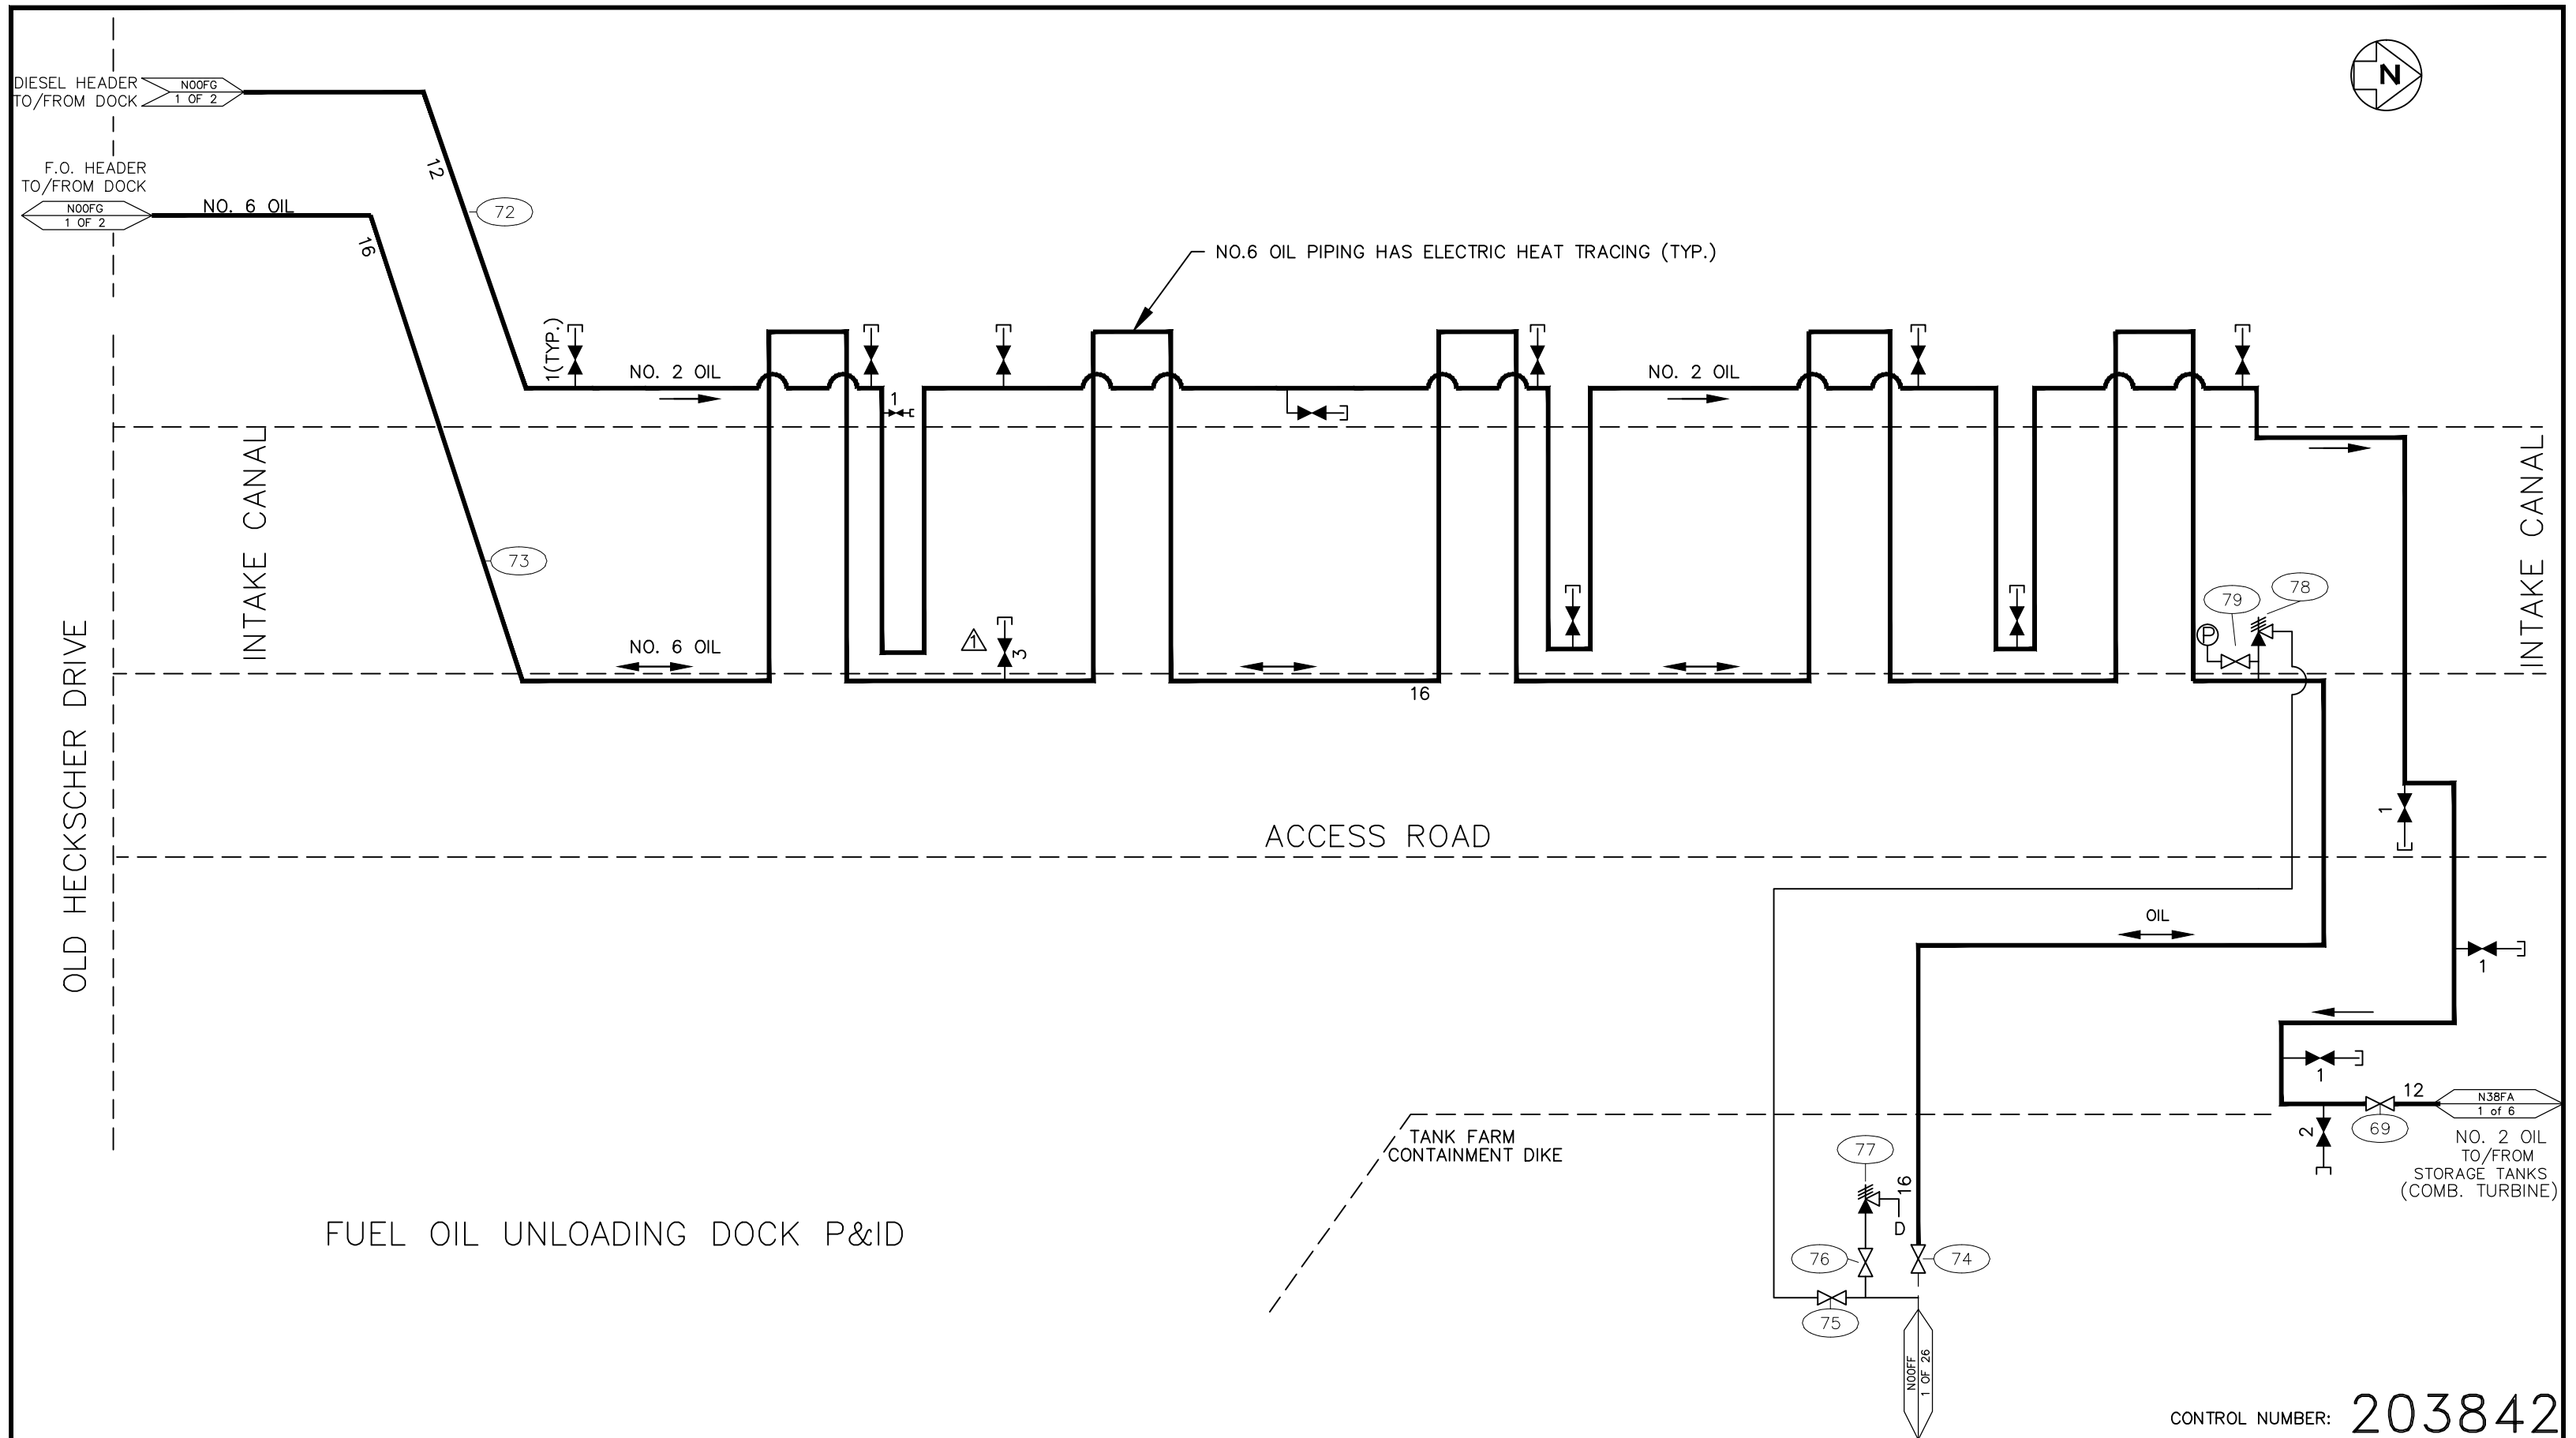

FUEL OIL UNLOADING DOCK P&ID

CONTROL NUMBER: 203842

NOTE: ALL PIPING IS CLASS 151.

					JEA PLANT SCHEMATIC	
					UNIT: N00	CRAFT: MECH
					GROUP: F – FUEL	
					SYSTEM: G – UNLOADING DOCK	
3	EAP	3/31/04	GENERAL REVISIONS	DEB	JEA DWG. No. M30FG02	
2	EAP	3/23/04	SYSTEM WALKDOWN	DEB		
REV	DRWN	DATE	DESCRIPTION	APPR BY	SHEET 2 OF 2	